


- NOTES**
1. ALL DIMENSIONS SHALL BE CHECKED AND CO-RELATED WITH THE STRUCTURAL DRAWINGS AND ANY AMBIGUITY SHALL BE IMMEDIATELY BROUGHT TO THE NOTICE OF THE ARCHITECT BEFORE COMMENCEMENT OF THE WORK.
 2. ALL DIMENSIONS ARE IN CENTIMETERS UNLESS AND OTHERWISE SPECIFIED.
 3. ALL LEVELS ARE FINISHED LEVELS.
 4. ALL MARGINS, CLEARANCES ETC. REQUIRED AS PER BYE LAWS SHOULD BE CHECKED AND PROVIDED BY THE CONTRACTOR AND ANY DISCREPANCIES FOUND SHOULD BE IMMEDIATELY BROUGHT TO THE NOTICE OF ARCHITECT BEFORE COMMENCEMENT OF WORK.
 5. FOR DETAILS OF ALL CUTOUTS IN SLABS AND BEAMS REFER SERVICES CONSULTANTS DRAWINGS.
 6. FOR STAIRCASE DETAILS REFER DRAWING NO. 5.1
 7. FOR TOILET DETAILS REFER DRAWING NO. 6.1
 8. FOR DOOR DETAILS REFER DRAWING NO. 8.1
 9. FOR WINDOW DETAILS REFER DRAWING NO. 9.1
 10. FOR KITCHEN - PANTRY DETAILS REFER DRAWING NO. 10.1
 11. FOR MISCELLANEOUS DETAILS REFER DRAWING NO. 29.1
 12. FOR VERANDAH DETAILS REFER DRAWING NO. 31.1

LEGEND

S.NO.	DESCRIPTION	SYMBOL
1.	DRINKING W. PIPE	
2.	DOMESTIC WATER PIPE	
3.	FLUSHING WATER PIPE	
4.	SEWER PIPE LINE	
5.	STORM PIPE LINE	
MH	SEWER MANHOLE	
GT	GULLY TRAP	
SMH	STORM MANHOLE	
CB	CATCH BASIN	

NOTE :-
1. ALL MANHOLE ARE PLACED AT DISTANCE OF 30MTR APART.

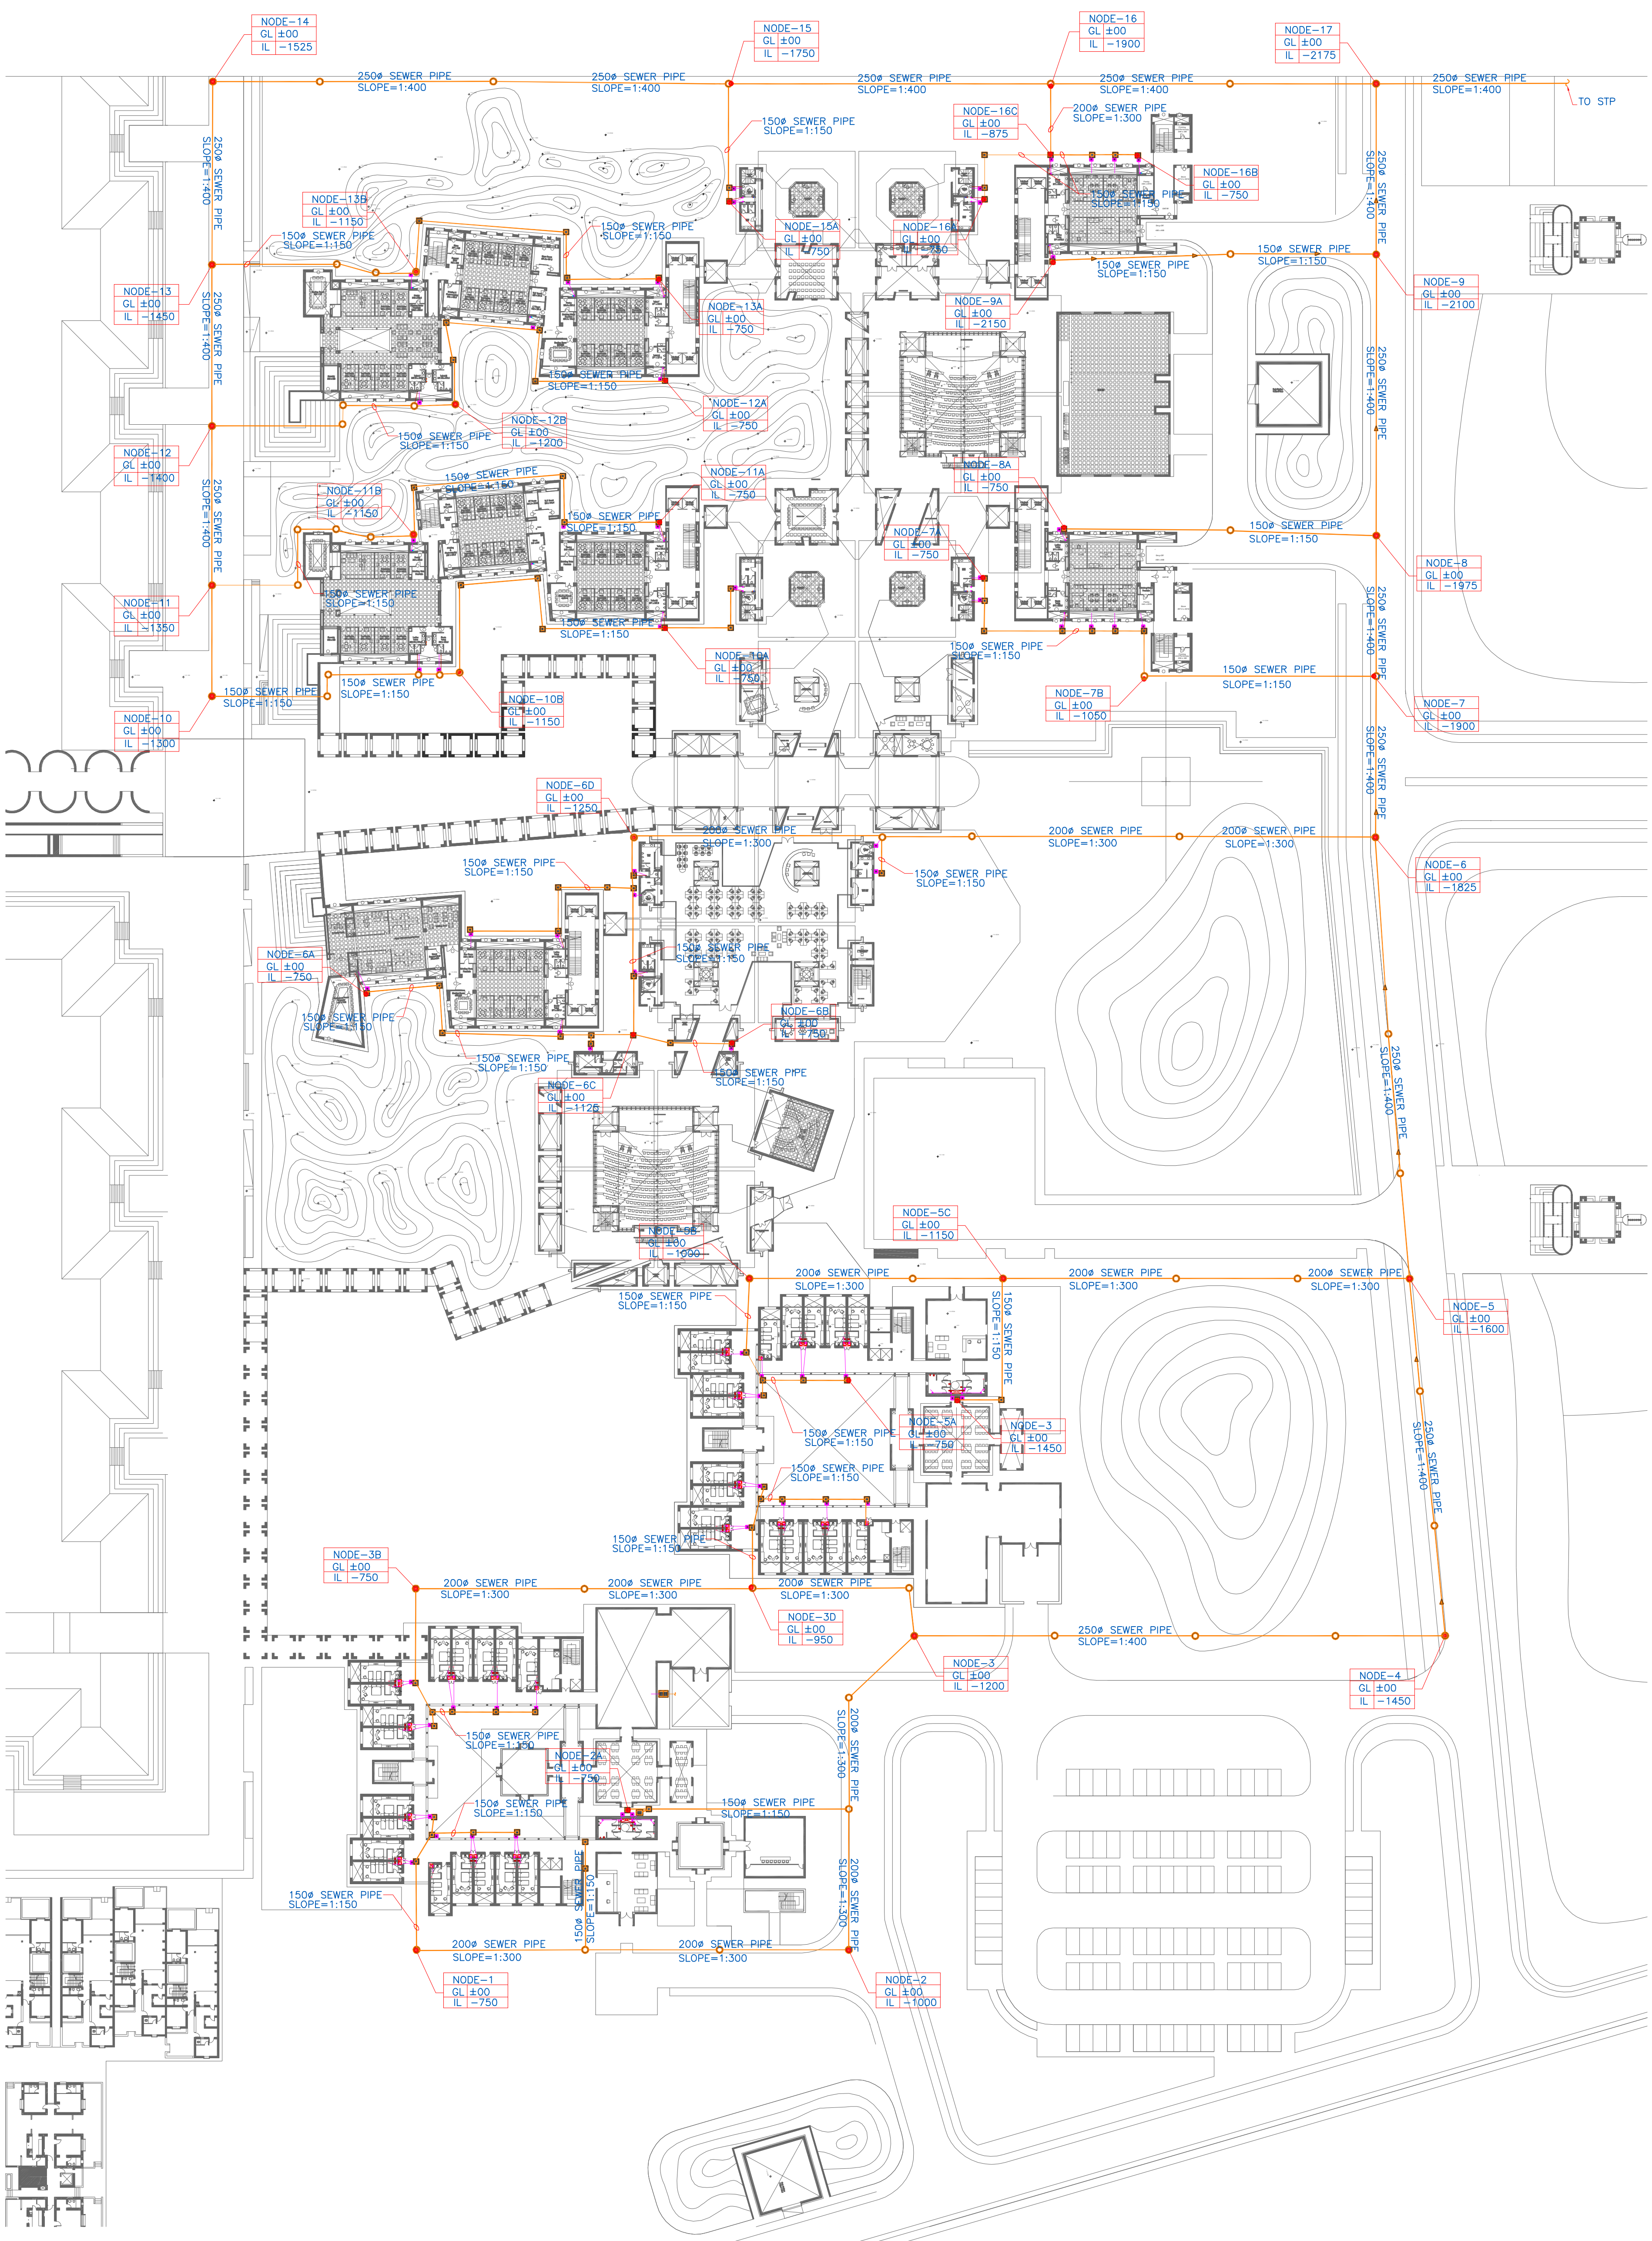

No.	Date.	Remarks.
Revisions		

Date	Prints	Issued to	Date	Prints	Issued to
Distribution of Prints					

Key Plan

Consultants
 Structural Consultants
 VR SHAH Consulting Engineers

Services Consultants

 dbHMS
 2nd Floor, D-62, Sector -2,
 Noida - 201301
 www.dbhms.in

Landscape Consultants
 Earthscapes Consultancy Pvt Ltd

Road and Pathways Consultants
 Arhmm Infra Consultants LLP

Project
 Nalanda University, Academic Spine, Rajgir, Bihar

Title
 SITE PLAN - SEWERAGE LAYOUT FOR TENDER

Dealt : JK	Drawing No.
Checked : AT	NUC(1)-AS-P2.1
Scale : 1:500	
Date : 07.07.2016	

VASTU SHILPA CONSULTANTS
 Architects | Planners | Urban Designers
 'Sangath', Thaltej Road, Ahmedabad - 380054
 Phone: 079 - 27454537 Fax: 079 - 27452006
 www.sangath.org e-mail: vsc@sangath.org


1 ACADEMIC SPINE : SEWERAGE LAYOUT

- NOTES**
1. ALL DIMENSIONS SHALL BE CHECKED AND CO-RELATED WITH THE STRUCTURAL DRAWINGS AND ANY AMBIGUITY SHALL BE IMMEDIATELY BROUGHT TO THE NOTICE OF THE ARCHITECT BEFORE COMMENCEMENT OF THE WORK.
 2. ALL DIMENSIONS ARE IN CENTIMETERS UNLESS OTHERWISE SPECIFIED.
 3. ALL LEVELS ARE FINISHED LEVELS.
 4. ALL MARGINS, CLEARANCES ETC. REQUIRED AS PER BYE LAWS SHOULD BE CHECKED AND PROVIDED BY THE CONTRACTOR AND ANY DISCREPANCIES FOUND SHOULD BE IMMEDIATELY BROUGHT TO THE NOTICE OF ARCHITECT BEFORE COMMENCEMENT OF WORK.
 5. FOR DETAILS OF ALL CUTOUTS IN SLABS AND BEAMS REFER SERVICES CONSULTANTS DRAWINGS.
 6. FOR STAIRCASE DETAILS REFER DRAWING NO. 5.1
 7. FOR TOILET DETAILS REFER DRAWING NO. 6.1
 8. FOR DOOR DETAILS REFER DRWG NO. 8.1
 9. FOR WINDOW DETAILS REFER DRWG NO. 9.1
 10. FOR KITCHEN - PANTRY DETAILS REFER DRWG NO. 10.1
 11. FOR MISCELLANEOUS DETAILS REFER DRAWING NO. 20.1
 12. FOR VERANDAH DETAILS REFER DRAWING NO. 31.1

LEGEND

S.NO.	DESCRIPTION	SYMBOL
1.	DRINKING W. PIPE	
2.	DOMESTIC WATER PIPE	
3.	FLUSHING WATER PIPE	
4.	SEWER PIPE LINE	
5.	STORM PIPE LINE	
MH	SEWER MANHOLE	
GT	GULLY TRAP	
SMH	STORM MANHOLE	
CB	CATCH BASIN	

- NOTE :-**
1. ALL MANHOLE ARE PLACED AT DISTANCE OF 30MTR APART.

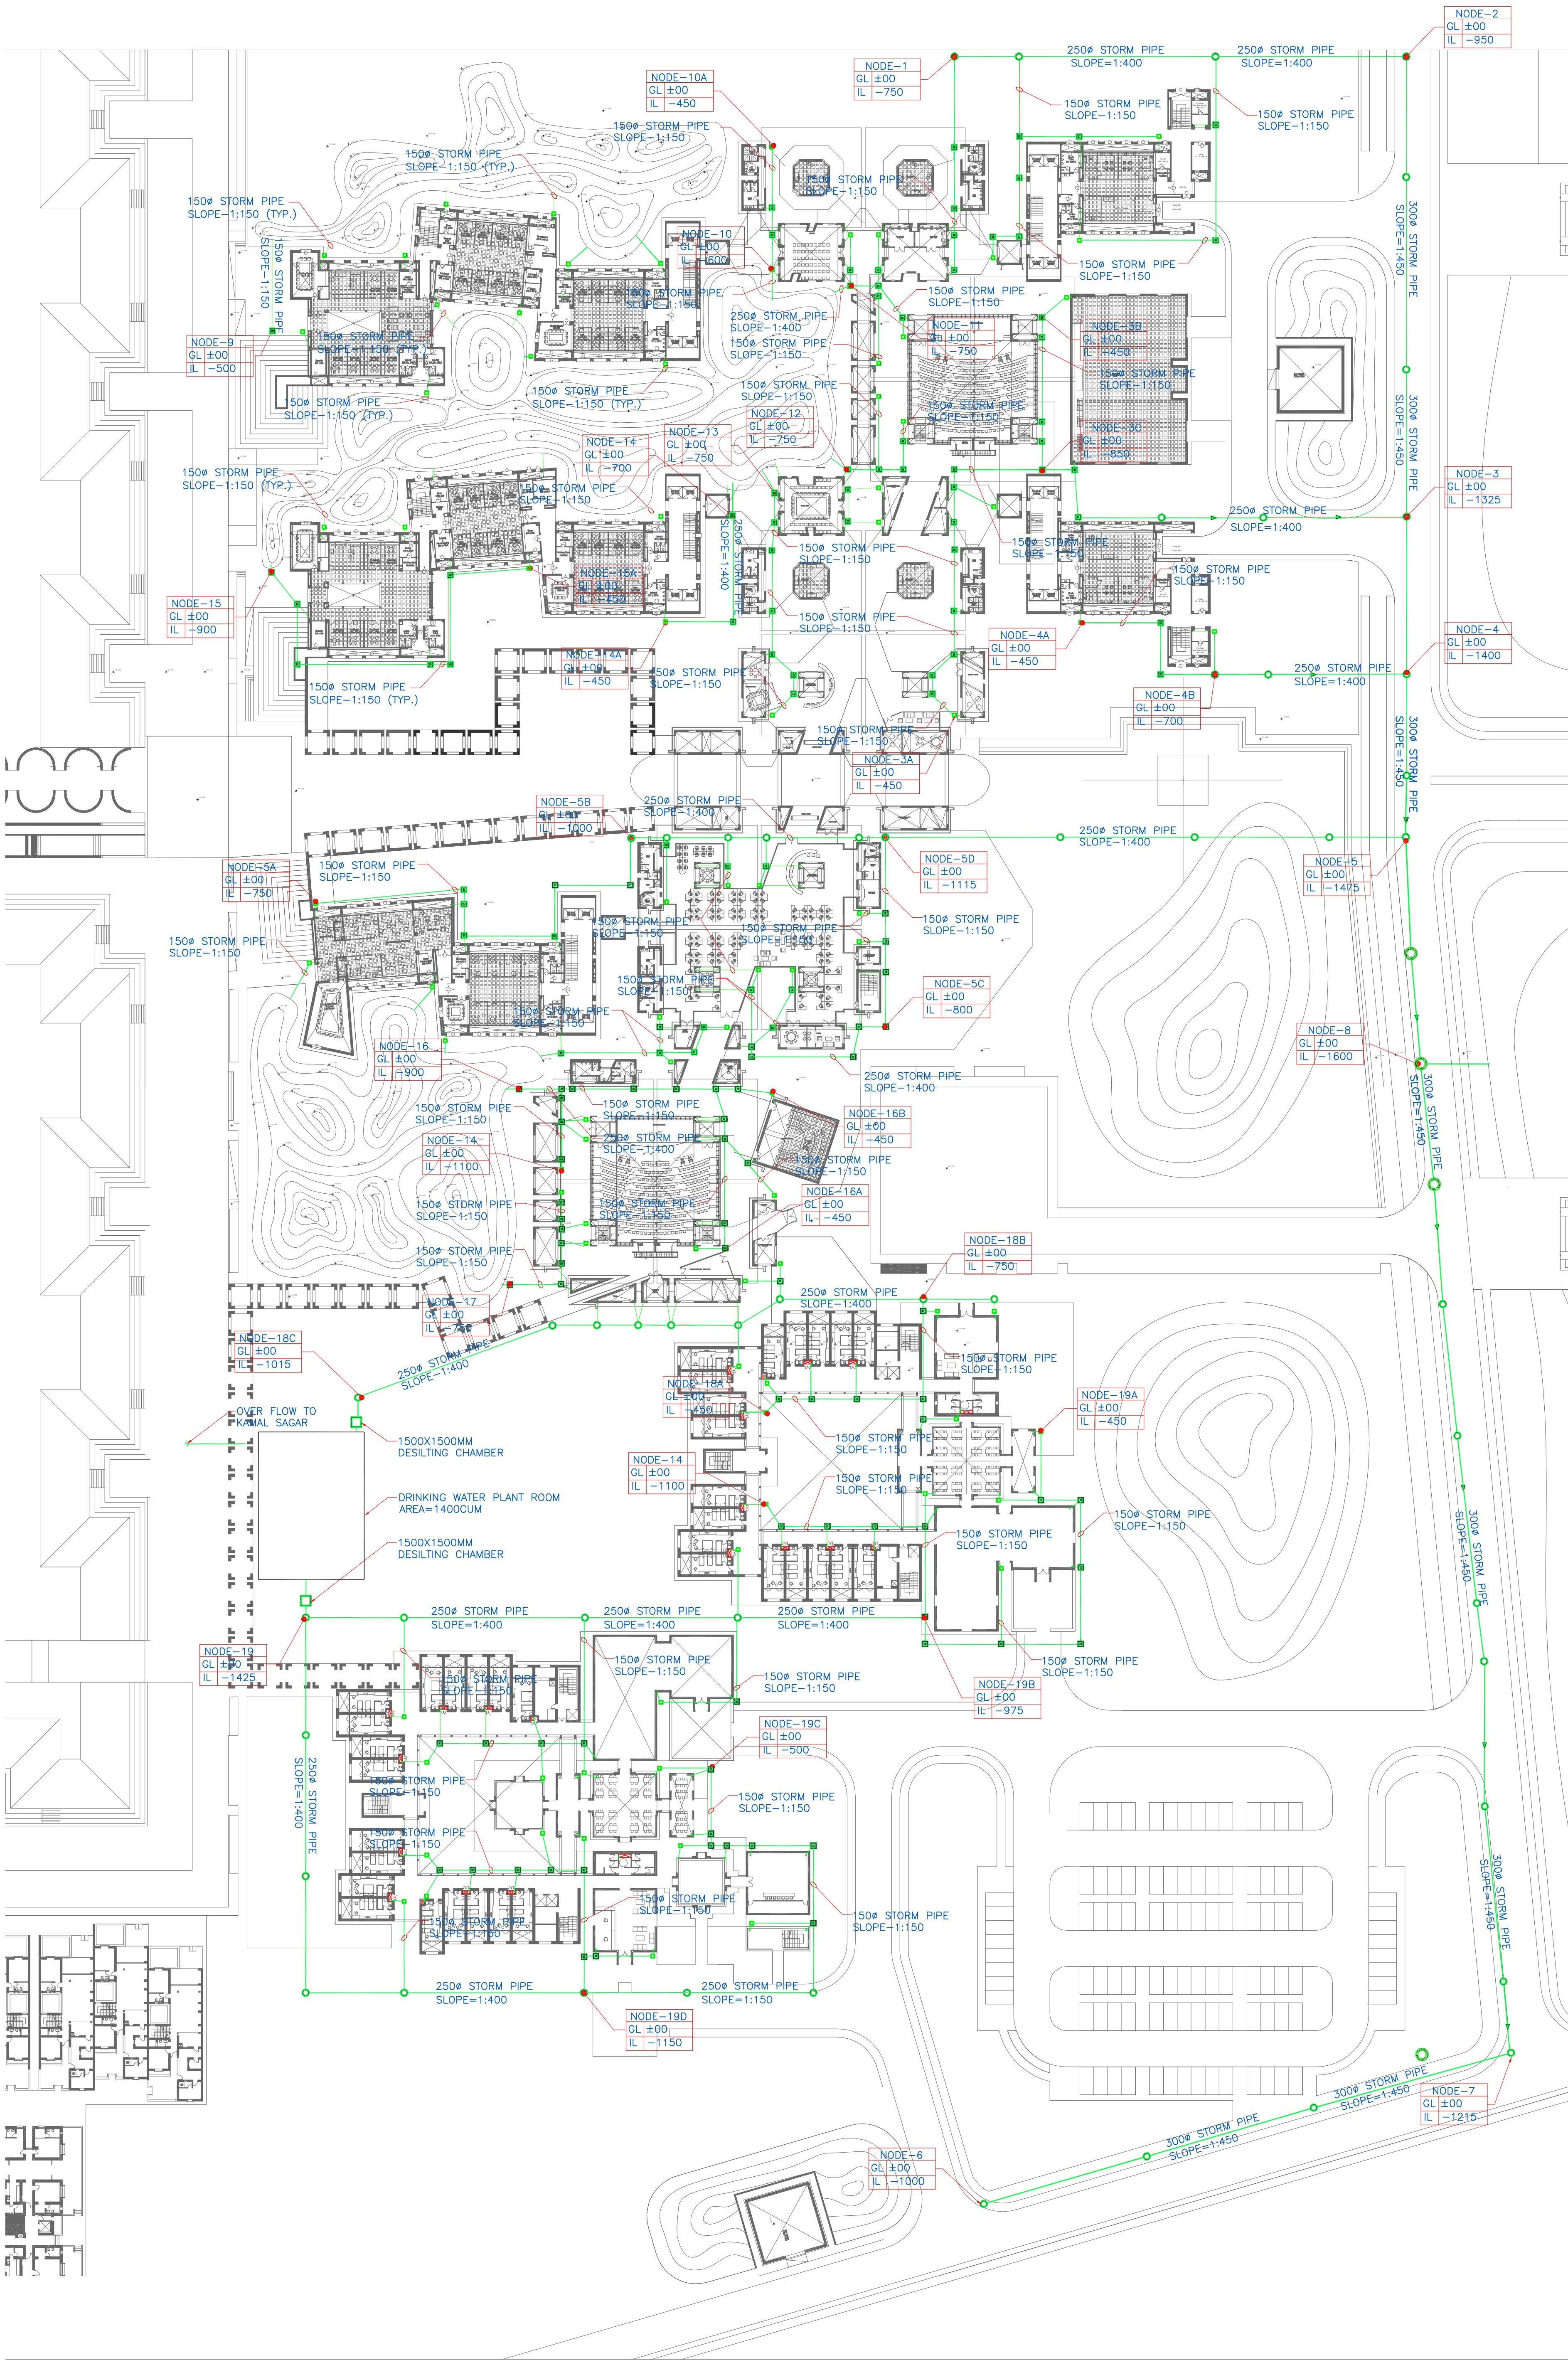

No.	Date.	Remarks.
Revisions		

Date	Prints	Issued to	Date	Prints	Issued to
Distribution of Prints					

Key Plan

- Consultants**
- Structural Consultants**
VR SHAH Consulting Engineers
 - Services Consultants**
dbHMS
2nd Floor, D-62, Sector -2,
Noida - 201301
www.dbhms.in
 - Landscape Consultants**
Earthscapes Consultancy Pvt Ltd
 - Road and Pathways Consultants**
Arhmm Infra Consultants LLP

Project
Nalanda University, Academic Spine, Rajgir, Bihar

Title
SITE PLAN - STORM LAYOUT FOR TENDER

Dealt : JK	Drawing No.
Checked : AT	NUC(1)-AS-P2.2
Scale : 1:500	
Date : 07.07.2016	

VASTU SHILPA CONSULTANTS
Architects | Planners | Urban Designers


'Sangath', Thaltej Road, Ahmedabad - 380054
Phone: 079 - 27454337 Fax: 079 - 27452006
www.sangath.org e-mail: vsc@sangath.org

1 ACADEMIC SPINE : STORM LAYOUT

- NOTES**
1. ALL DIMENSIONS SHALL BE CHECKED AND CO-RELATED WITH THE STRUCTURAL DRAWINGS AND ANY AMBIGUITY SHALL BE IMMEDIATELY BROUGHT TO THE NOTICE OF THE ARCHITECT BEFORE COMMENCEMENT OF THE WORK.
 2. ALL DIMENSIONS ARE IN CENTIMETERS UNLESS AND OTHERWISE SPECIFIED.
 3. ALL LEVELS ARE FINISHED LEVELS.
 4. ALL MARGINS, CLEARANCES ETC. REQUIRED AS PER BYE LAWS SHOULD BE CHECKED AND PROVIDED BY THE CONTRACTOR AND ANY DISCREPANCIES FOUND SHOULD BE IMMEDIATELY BROUGHT TO THE NOTICE OF ARCHITECT BEFORE COMMENCEMENT OF WORK.
 5. FOR DETAILS OF ALL CUTOUTS IN SLABS AND BEAMS REFER SERVICES CONSULTANT'S DRAWINGS.
 6. FOR STAIRCASE DETAILS REFER DRAWING NO. 5.1
 7. FOR TOILET DETAILS REFER DRAWING NO. 6.1
 8. FOR DOOR DETAILS REFER DRWG NO. 8.1
 9. FOR WINDOW DETAILS REFER DRWG NO. 9.1
 10. FOR KITCHEN - PANTRY DETAILS REFER DRWG NO. 10.1
 11. FOR MISCELLANEOUS DETAILS REFER DRAWING NO. 29.1
 12. FOR VERANDAH DETAILS REFER DRAWING NO. 31.1

LEGEND

S.NO.	DESCRIPTION	SYMBOL
1.	DRINKING W. PIPE	
2.	DOMESTIC WATER PIPE	
3.	FLUSHING WATER PIPE	
4.	SEWER PIPE LINE	
5.	STORM PIPE LINE	
MH	SEWER MANHOLE	
GT	GULLY TRAP	
SMH	STORM MANHOLE	
CB	CATCH BASIN	

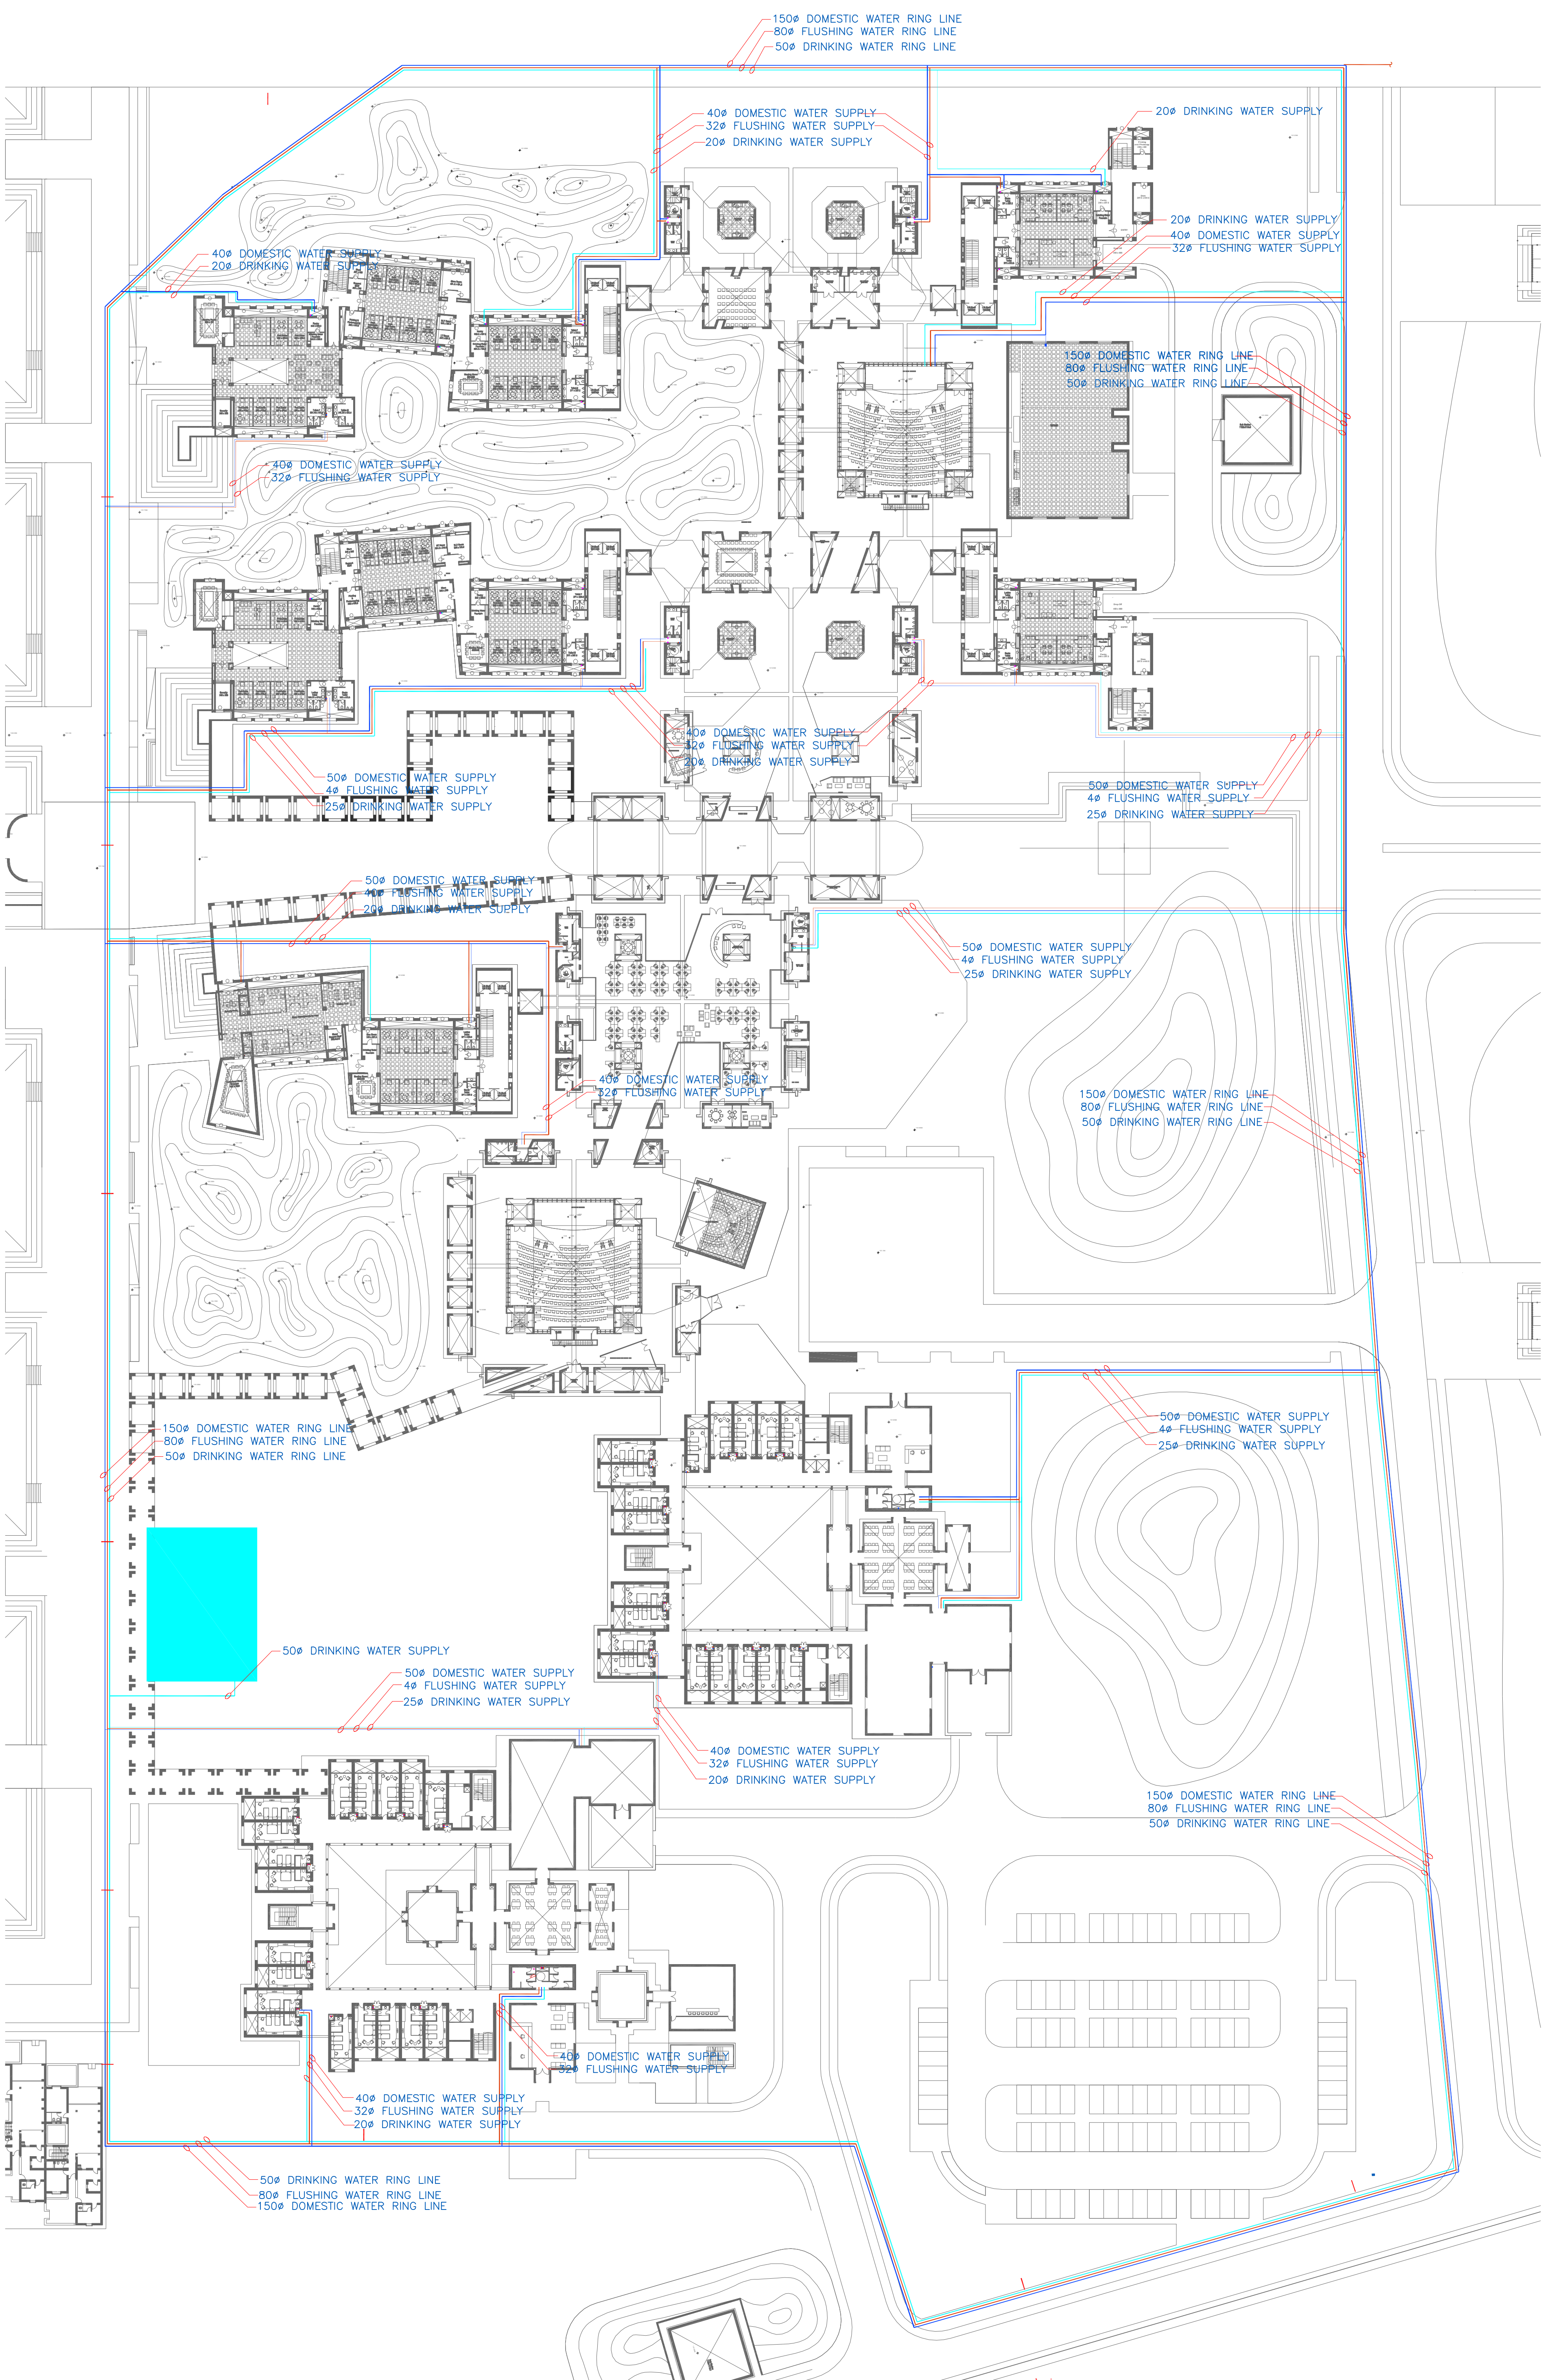

No.	Date.	Remarks.
Revisions		

Date	Prints	Issued to	Date	Prints	Issued to
Distribution of Prints					

Key Plan

Consultants

- Structural Consultants**
VR SHAH Consulting Engineers

- Services Consultants**
dbHMS
2nd Floor, D-62, Sector -2,
Noida - 201301
www.dbhms.in

- Landscape Consultants**
Earthscaapes Consultancy Pvt Ltd

- Road and Pathways Consultants**
Arhmm Infra Consultants LLP

Project

Nalanda University, Academic Spine, Rajgir, Bihar

Title

SITE PLAN - WATER SUPPLY LAYOUT
TENDER LAYOUT

Dealt :	JK	Drawing No.	NUC(1)-AS-P2.3
Checked :	AT		
Scale :	1:500		
Date :	07.07.2016		

VASTU SHILPA CONSULTANTS
Architects | Planners | Urban Designers

'Sangath', Thaltej Road, Ahmedabad - 380054
Phone: 079 - 27454537 Fax: 079 - 27452006
www.sangath.org e-mail: vsc@sangath.org

1 ACADEMIC SPINE : WATER SUPPLY LAYOUT