


- NOTES**
1. ALL DIMENSIONS SHALL BE CHECKED AND CORRELATED WITH THE STRUCTURAL DRAWINGS AND ANY AMBIGUITY SHALL BE IMMEDIATELY BROUGHT TO THE NOTICE OF THE ARCHITECT BEFORE COMMENCEMENT OF THE WORK.
  2. ALL DIMENSIONS ARE IN CENTIMETERS UNLESS OTHERWISE SPECIFIED.
  3. ALL LEVELS ARE FINISHED LEVELS.
  4. ALL MARGINS, CLEARANCES ETC. REQUIRED AS PER BY-LAWS SHOULD BE CHECKED AND PROVIDED BY THE CONTRACTOR AND ANY DISCREPANCIES FOUND SHOULD BE IMMEDIATELY BROUGHT TO THE NOTICE OF ARCHITECT BEFORE COMMENCEMENT OF WORK.

**ELECTRICAL LEGEND:**

	TV AERIAL SOCKET OUTLET AT 625mm SFL.
	INTERCOM SOCKET OUTLET AT 625mm SFL.
	DATA POINT
	DISTRIBUTION BOARD : 1600mm ABOVE SFL.

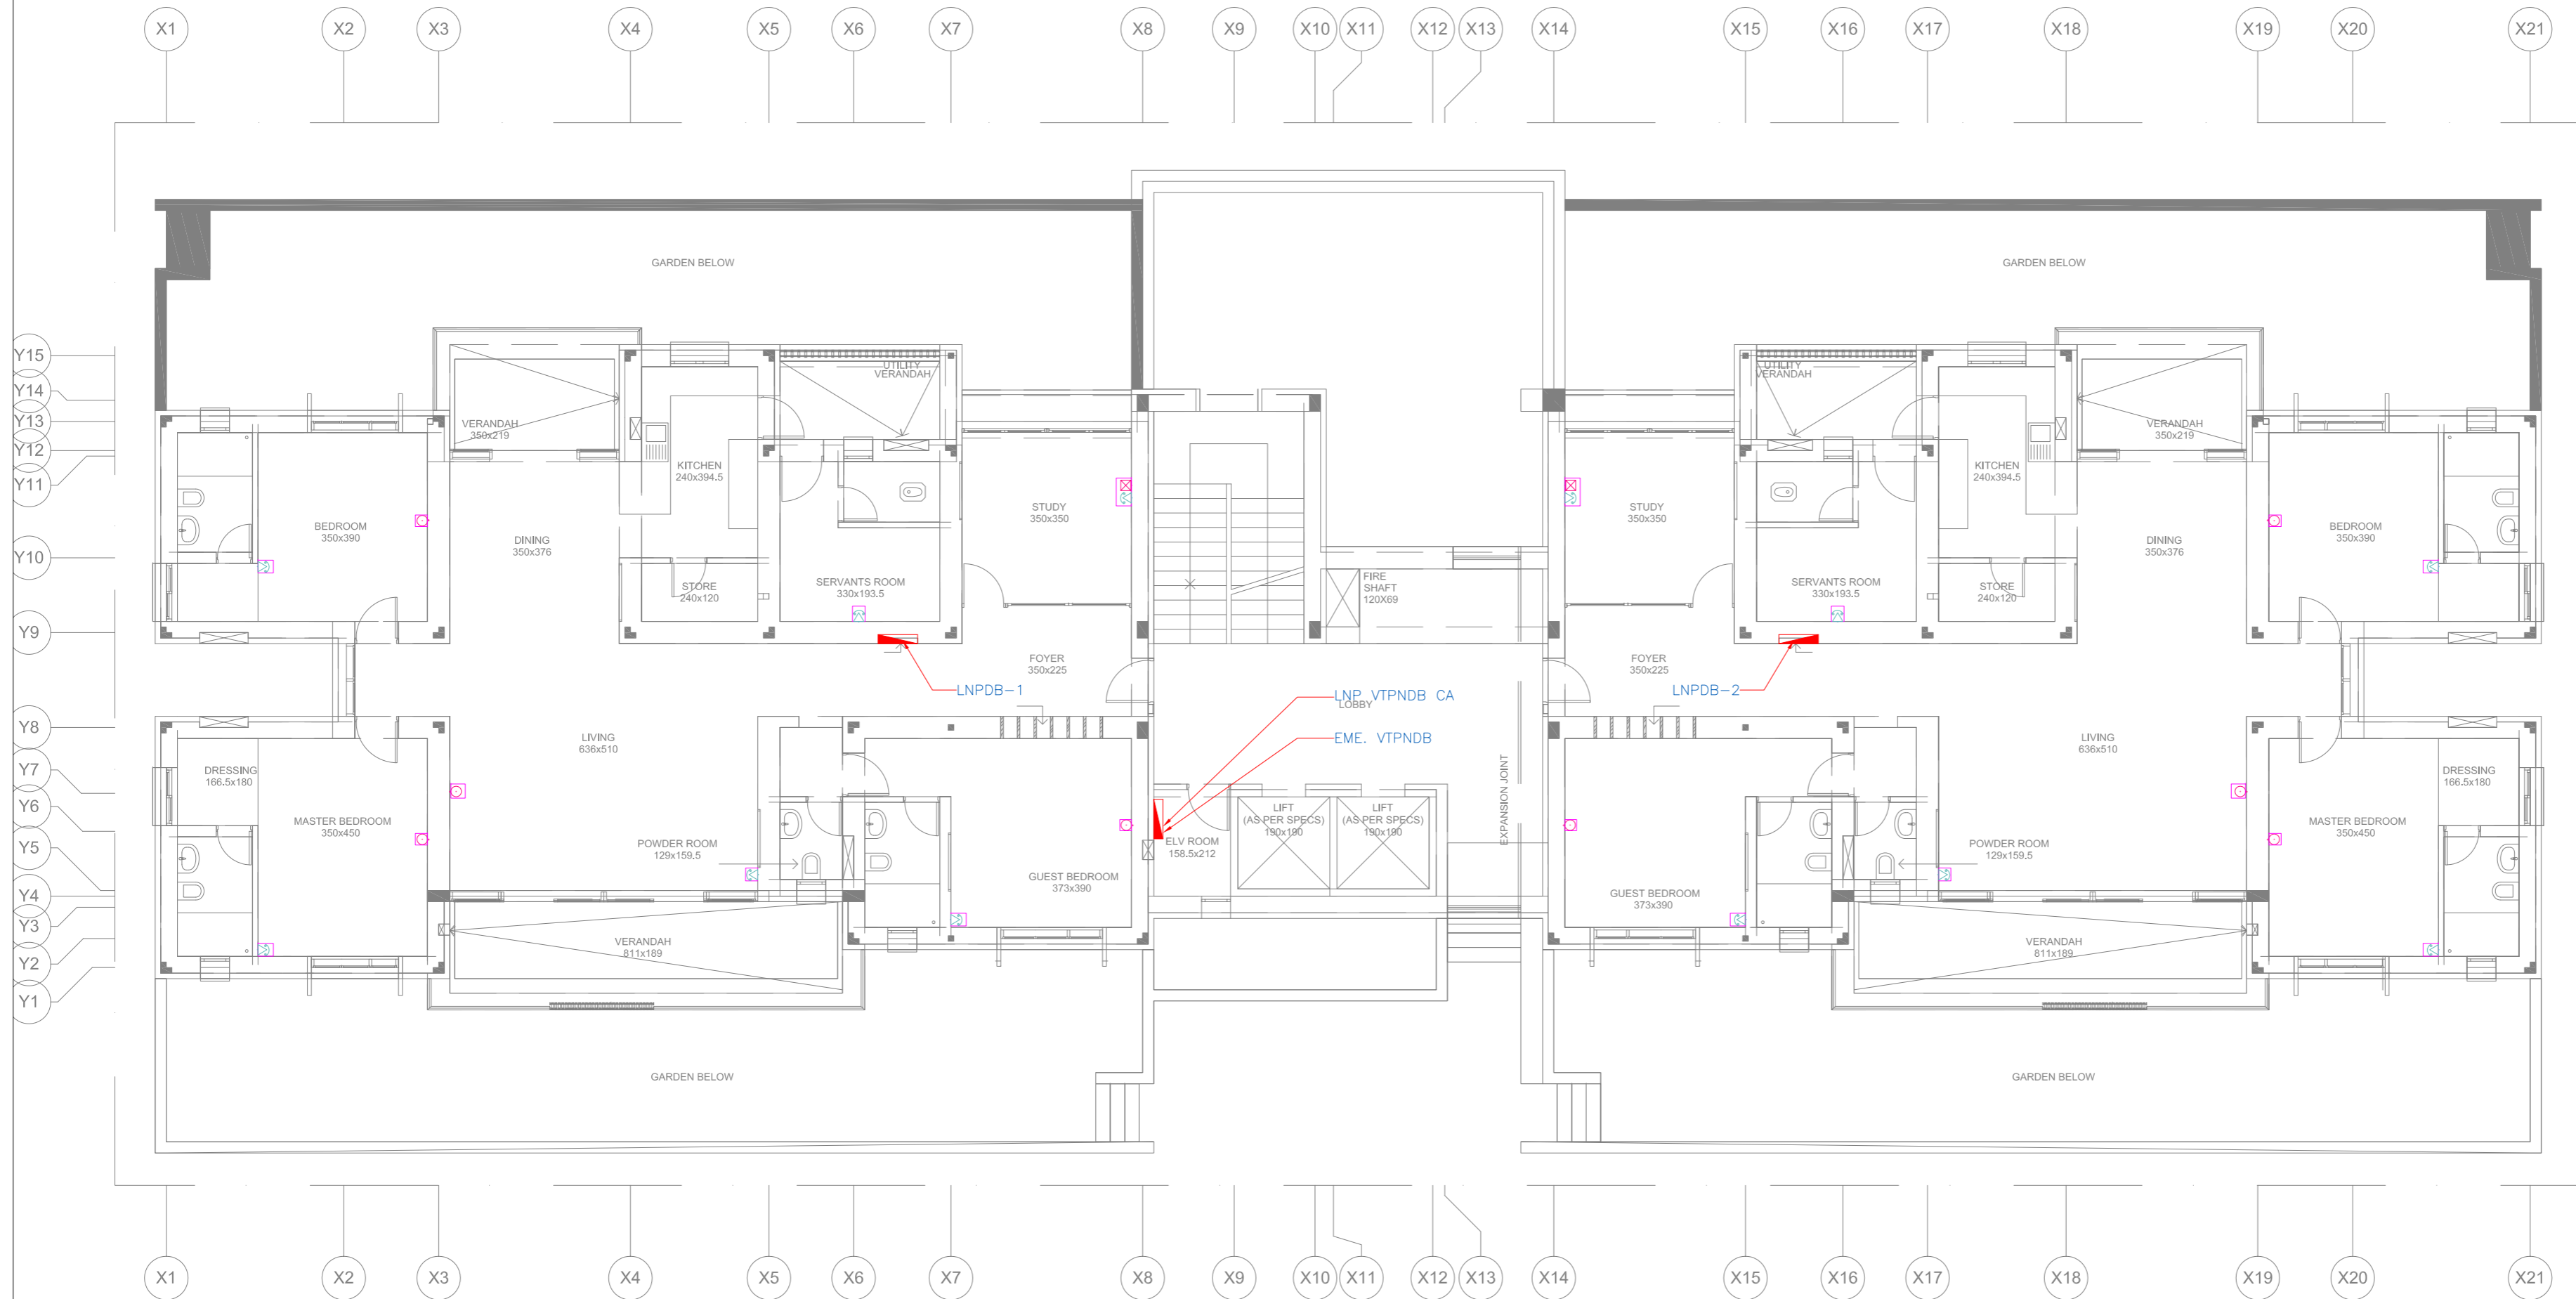

No.	Date.	Remarks.
Revisions		
Date	Prints	Issued to
Distribution of Prints		
Key Plan		

- Consultants**
- Structural Consultants**  
VR SHAH Consulting Engineers
  - Services Consultants**  
dbHMS  
2nd Floor, D-62, Sector -2,  
Noida - 201301  
www.dbhms.in
  - Landscape Consultants**  
Earthscapes Consultancy Pvt Ltd
  - Road and Pathways Consultants**  
Arhmm Infra Consultants LLP

Project  
**Nalanda University, Rajgir, Bihar**

Title  
FIRST FLOOR PLAN -ELV LAYOUT

FOR TENDER

Dealt : V.K	Drawing No.
Checked : M.T	NUC(1)-FAH-1B-E2.2.3
Scale : 1:75	
Date : 03.06.2016	Approved By : V.M.

**VASTU SHILPA CONSULTANTS**  
Architects | Planners | Urban Designers

'Sangathi', Thaltej Road, Ahmedabad - 380054  
Phone: 079 - 27454537 Fax: 079 - 27452006  
www.sangathi.org e-mail: vsc@sangathi.org

**3 First Floor Plan : ELV Layout**