


| LEGEND | | |
|--------|--------|----------------------------------------------|
| S.No | SYMBOL | DESCRIPTION |
| 1. | | 9LTR WATER CO ₂ FIRE EXTINGUISHER |
| 2. | | 2KG DRY POWDER FIRE EXTINGUISHER |
| 3. | | FIRE HOSE REEL |
| 4. | | BALL VALVE |

- NOTES**
- ALL DIMENSIONS SHALL BE CHECKED AND CO-RELATED WITH THE STRUCTURAL DRAWINGS AND ANY AMBIGUITY SHALL BE IMMEDIATELY BROUGHT TO THE NOTICE OF THE ARCHITECT BEFORE COMMENCEMENT OF THE WORK.
 - ALL DIMENSIONS ARE IN CENTIMETERS UNLESS AND OTHERWISE SPECIFIED.
 - ALL LEVELS ARE FINISHED LEVELS.
 - ALL MARGINS, CLEARANCES ETC. REQUIRED AS PER BYE-LAWS SHOULD BE CHECKED AND PROVIDED BY THE CONTRACTOR AND ANY DISCREPANCIES FOUND SHOULD BE IMMEDIATELY BROUGHT TO THE NOTICE OF ARCHITECT BEFORE COMMENCEMENT OF WORK.

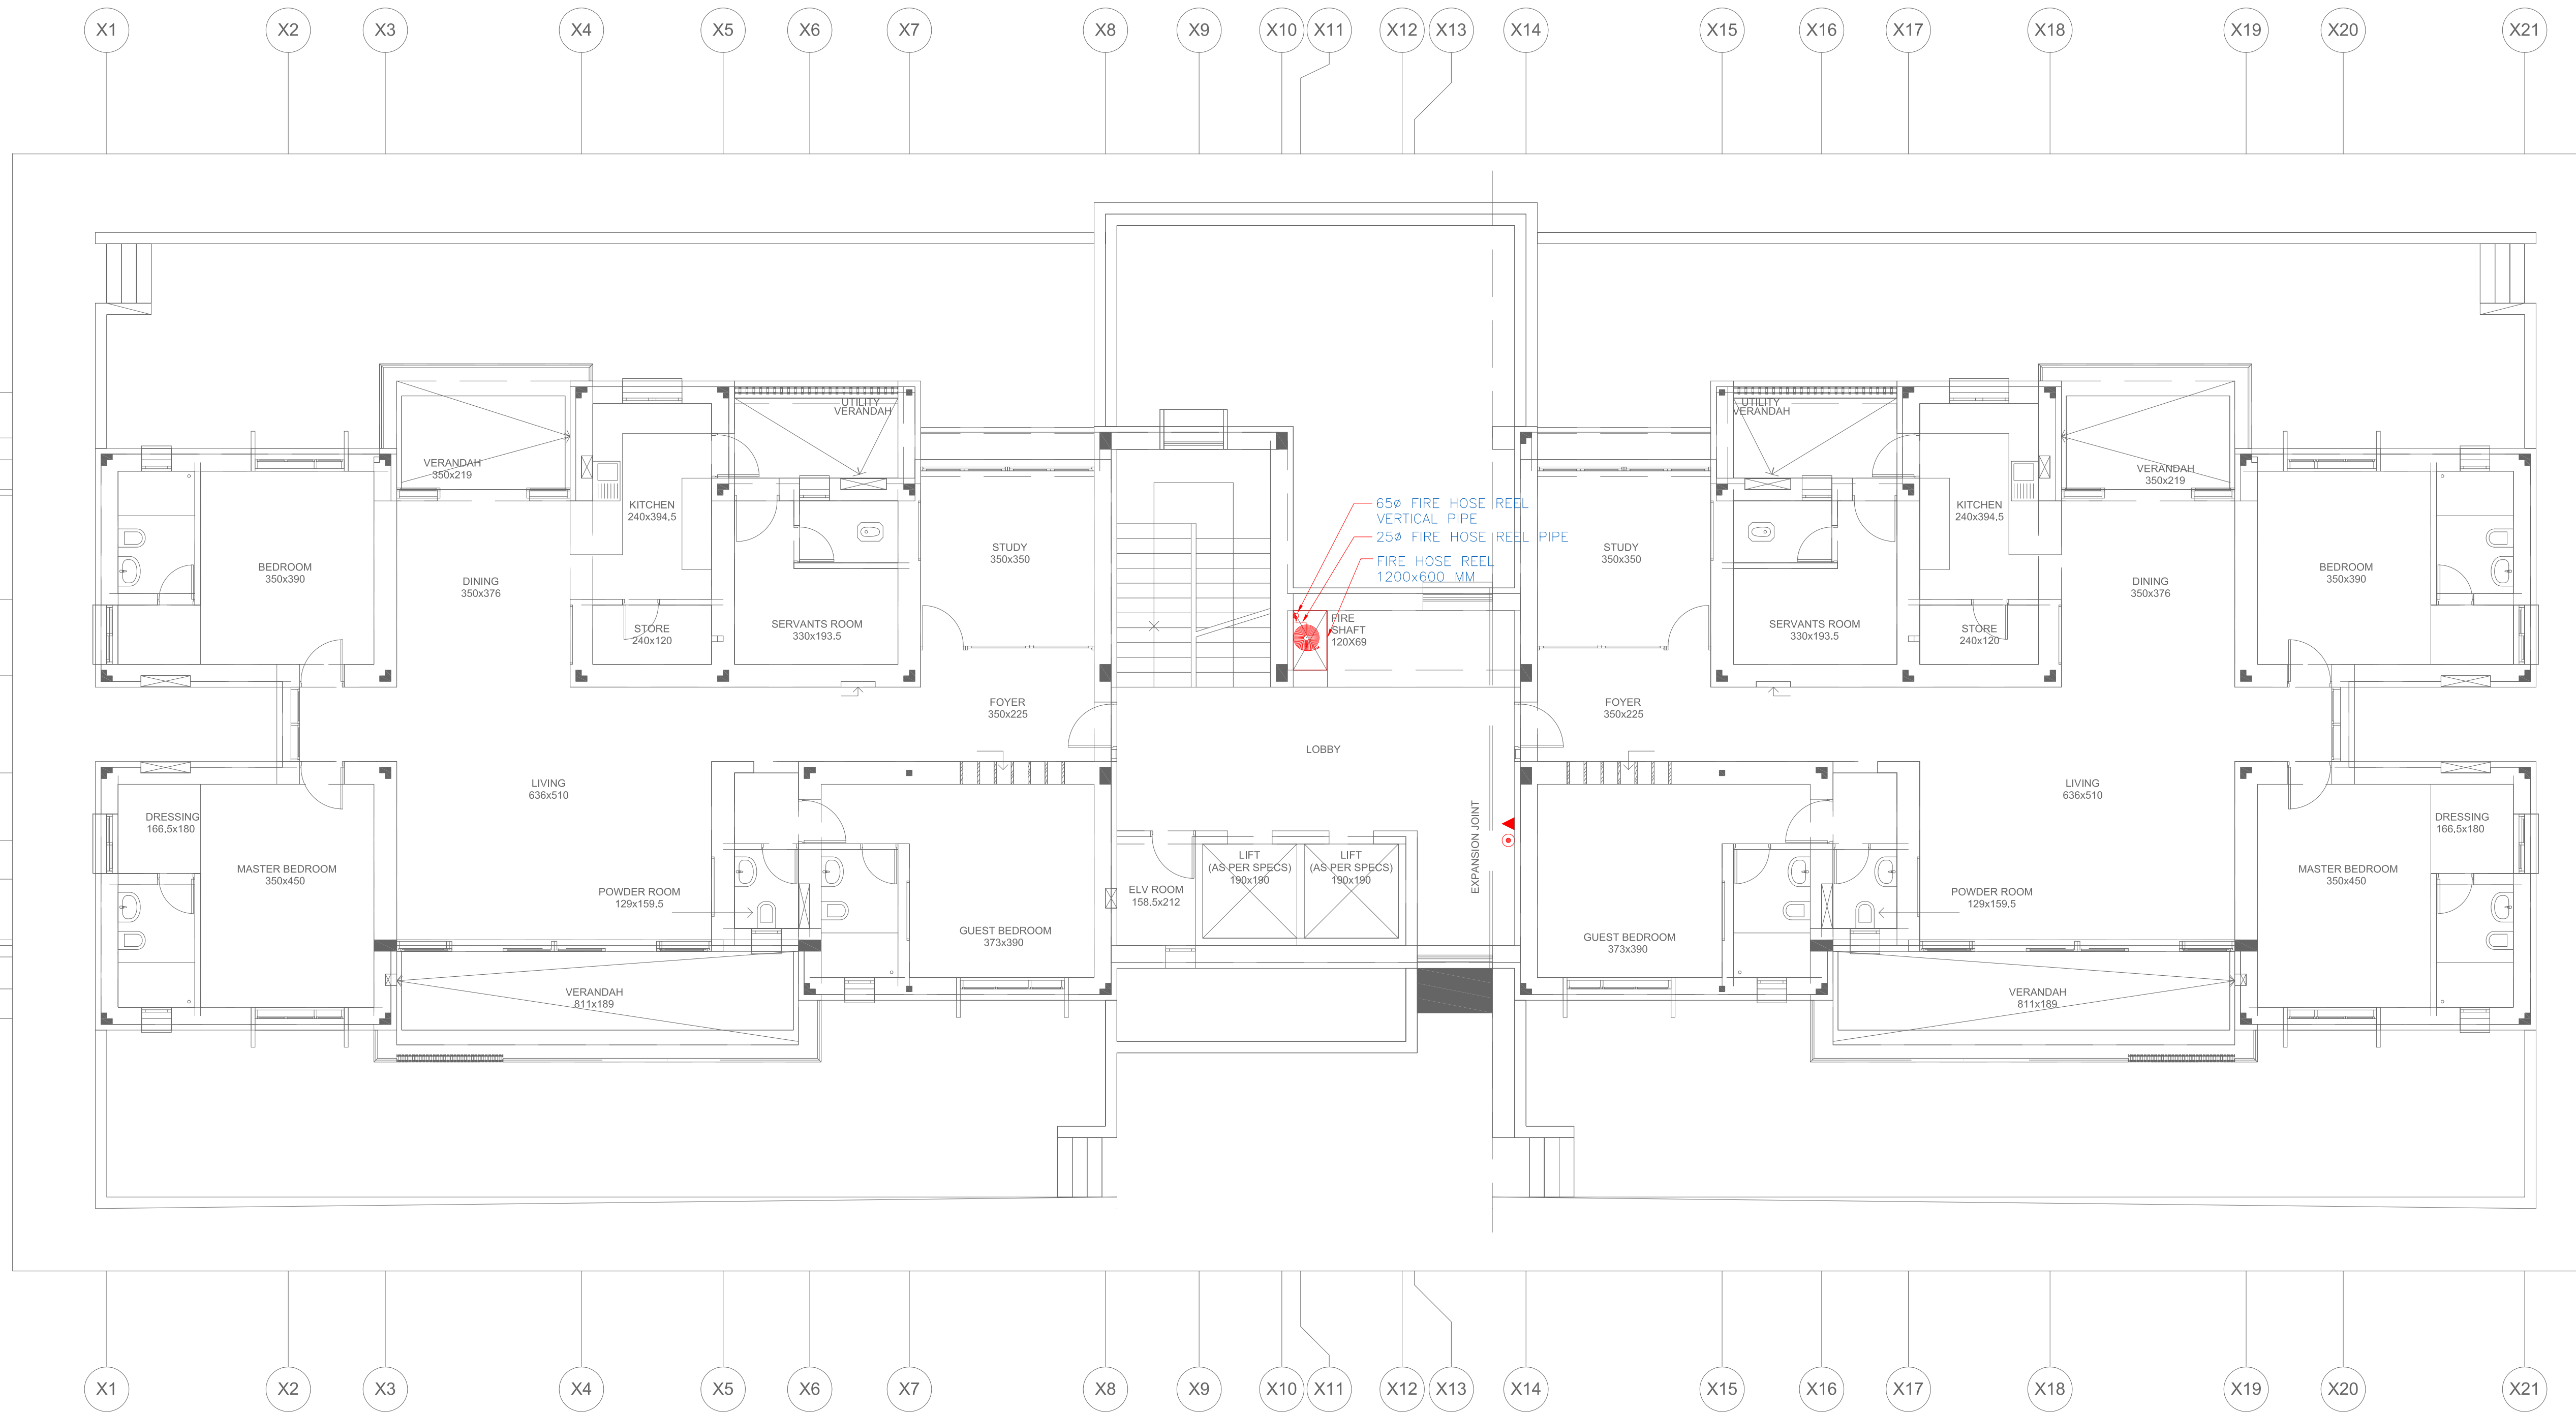


| No. | Date. | Remarks. |
|-----|-------|----------|
|-----|-------|----------|

Revisions

| Date | Prints | Issued to | Date | Prints | Issued to |
|------|--------|-----------|------|--------|-----------|
|------|--------|-----------|------|--------|-----------|

Distribution of Prints

Key Plan

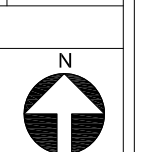

Consultants

- Structural Consultants**
VR SHAH Consulting Engineers
- Services Consultants**
dbHMS
2nd Floor, D-62, Sector -2,
Noida - 201301
www.dbhms.in
- Landscape Consultants**
Earthscapes Consultancy Pvt Ltd
- Road and Pathways Consultants**
Ahhmm Infra Consultants LLP

Project

Nalanda University, Rajgir, Bihar

Title

SECOND FLOOR PLAN -
FIRE FIGHTING

FOR TENDER

Deal : JK

Checked : AT

Scale : 1:75

Date : 20.05.2016

Drawing No. NUC(1)-FAH-1B-FR2.3

Approved By : VM

VASTU SHILPA CONSULTANTS

Architects | Planners | Urban Designers

'Sangath', Thaltej Road, Ahmedabad - 380054

Phone: 079 - 27454537 Fax: 079 - 27452006

www.sangath.org e-mail: vsc@sangath.org

1 SECOND FLOOR PLAN: FIRE FIGHTING

