


LEGEND		
S.No	SYMBOL	DESCRIPTION
1.		9LTR WATER CO ₂ FIRE EXTINGUISHER
2.		2KG DRY POWDER FIRE EXTINGUISHER
3.		FIRE HOSE REEL
4.		BALL VALVE

- NOTES**
1. ALL DIMENSIONS SHALL BE CHECKED AND CO-RELATED WITH THE STRUCTURAL DRAWINGS AND ANY AMBIGUITY SHALL BE IMMEDIATELY BROUGHT TO THE NOTICE OF THE ARCHITECT BEFORE COMMENCEMENT OF THE WORK.
 2. ALL DIMENSIONS ARE IN CENTIMETERS UNLESS OTHERWISE SPECIFIED.
 3. ALL LEVELS ARE FINISHED LEVELS.
 4. ALL MARGINS, CLEARANCES ETC. REQUIRED AS PER BYE-LAWS SHOULD BE CHECKED AND PROVIDED BY THE CONTRACTOR AND ANY DISCREPANCIES FOUND SHOULD BE IMMEDIATELY BROUGHT TO THE NOTICE OF ARCHITECT BEFORE COMMENCEMENT OF WORK.

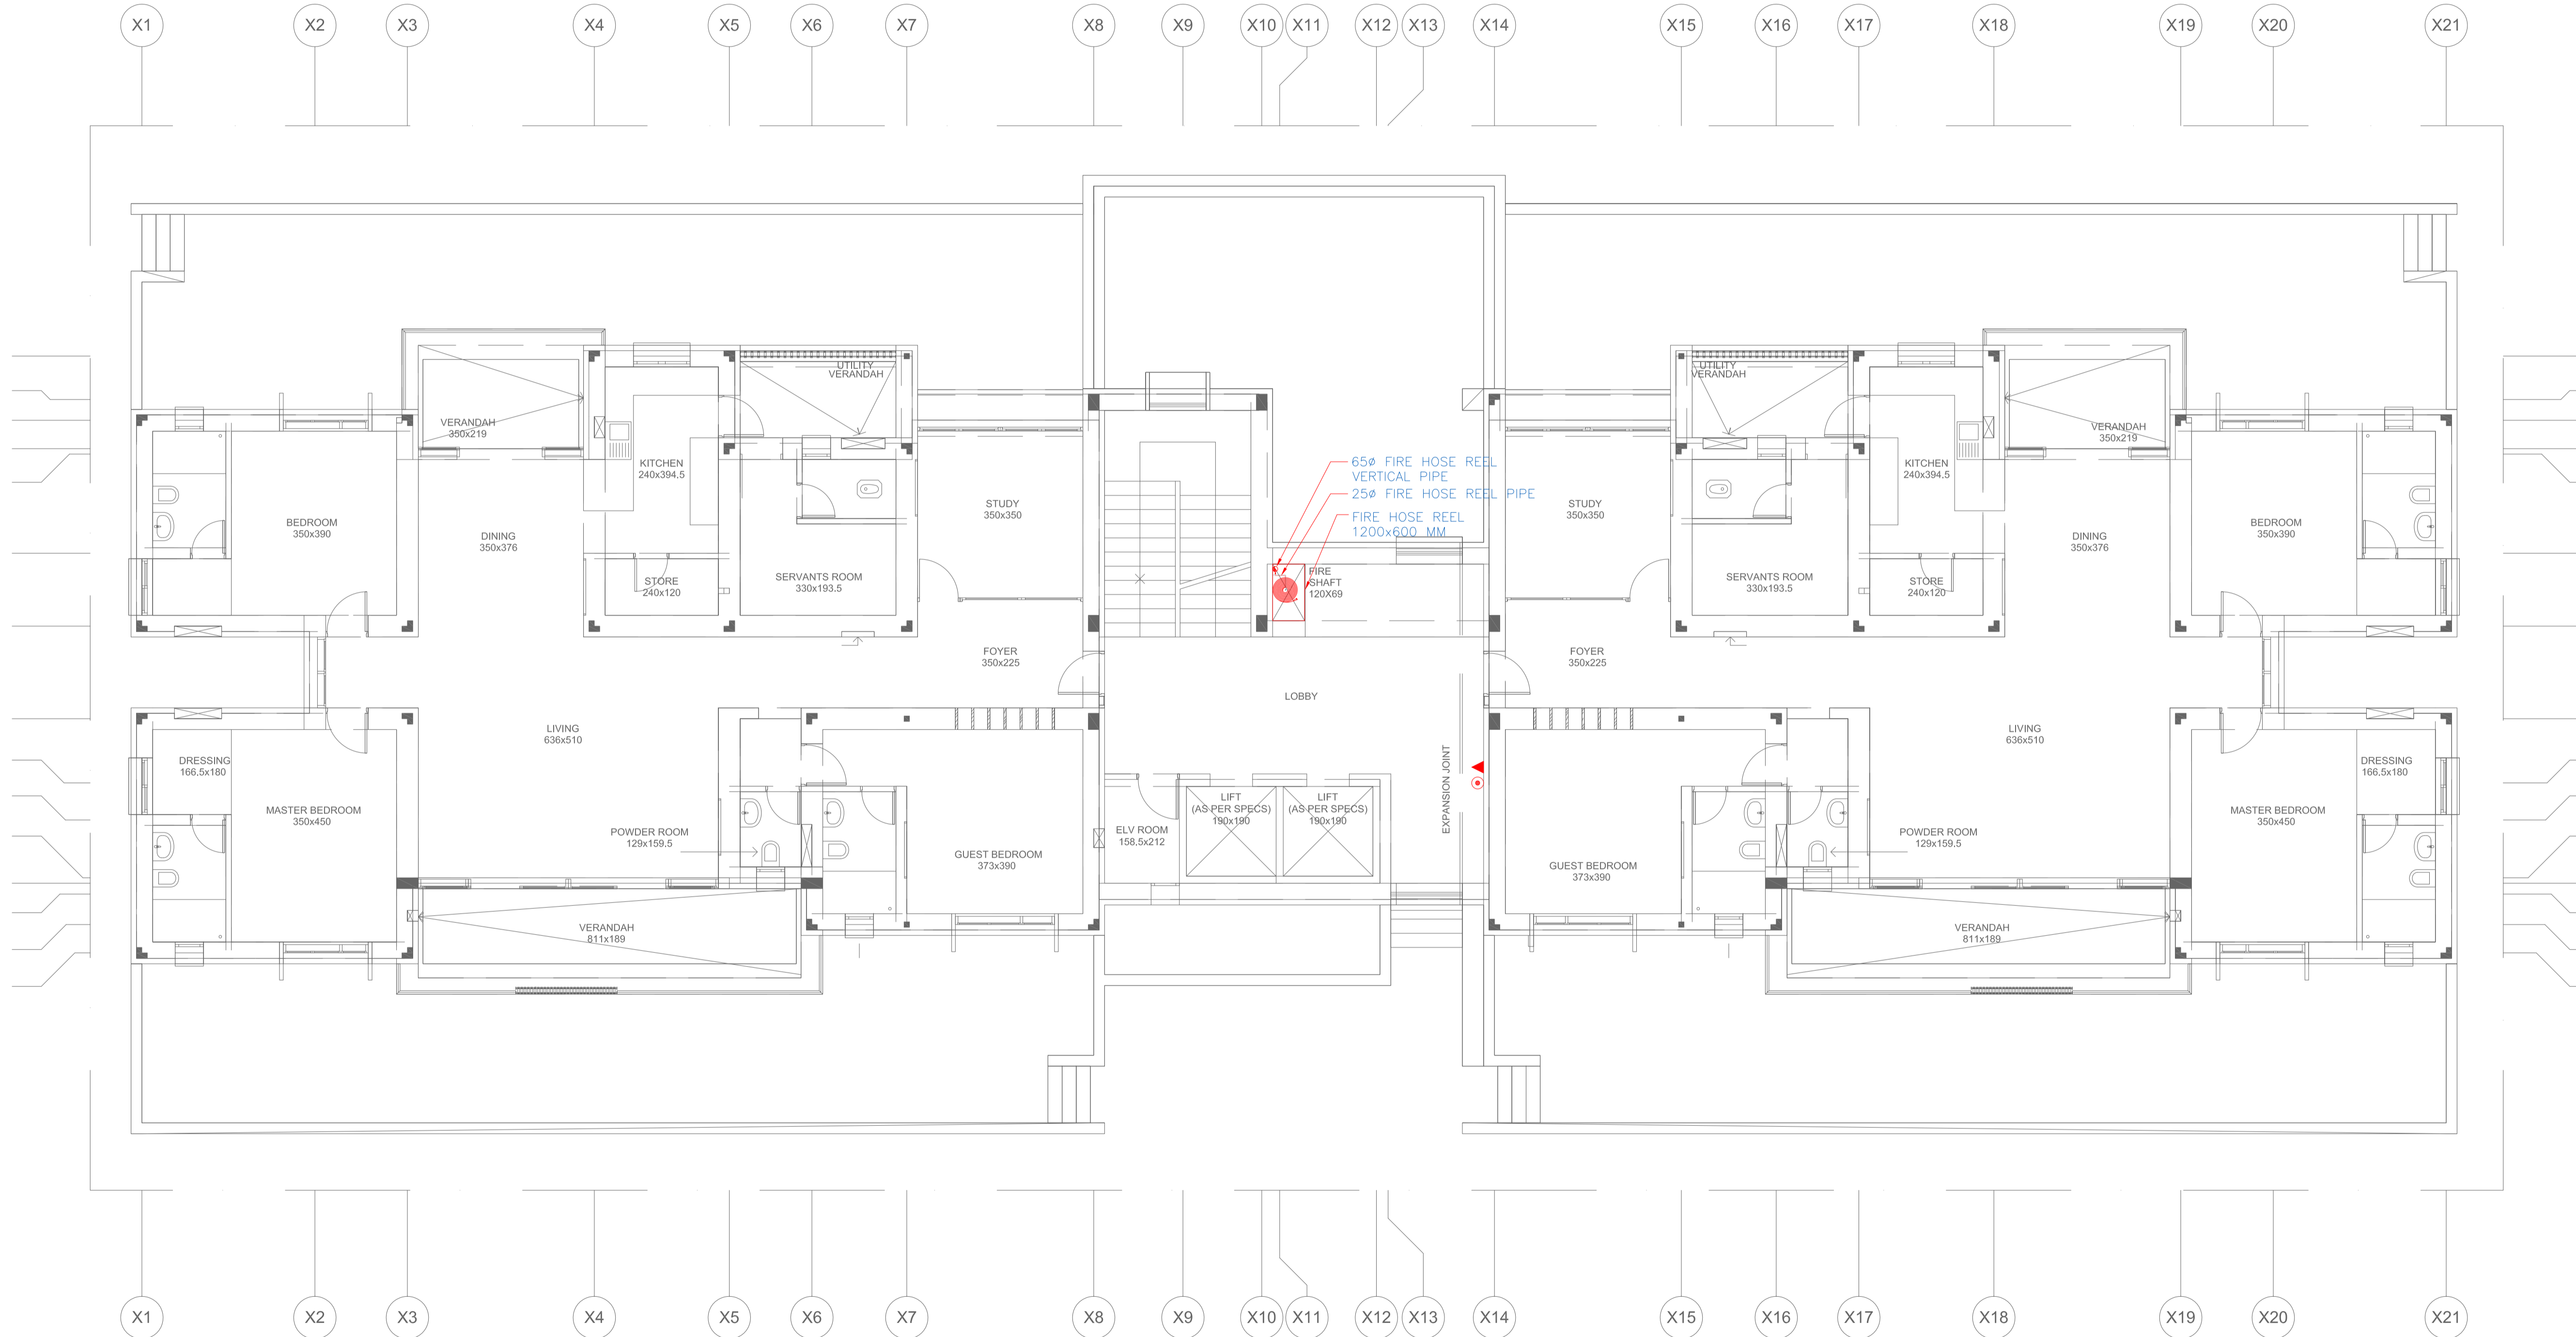


No.	Date.	Remarks.
-----	-------	----------

Revisions

Date	Prints	Issued to	Date	Prints	Issued to
------	--------	-----------	------	--------	-----------

Distribution of Prints

Key Plan

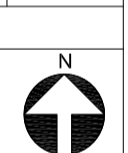

Consultants

Structural Consultants
VR SHAH Consulting Engineers

Services Consultants
dbHMS
2nd Floor, D-62, Sector -2,
Noida - 201301
www.dbhms.in

Landscape Consultants
Earthscapes Consultancy Pvt Ltd

Road and Pathways Consultants
Ahhmm Infra Consultants LLP

Project

Nalanda University, Rajgir, Bihar

Title

THIRD FLOOR PLAN –
FIRE FIGHTING
FOR TENDER

Deal :	JK	Drawing No.	
Checked :	AT		NUC(1)-FAH-1B-FF2.4
Scale :	1:75	Approved By :	VM
Date :	20.05.2016		

VASTU SHILPA CONSULTANTS
Architects | Planners | Urban Designers

‘Sangath’, Thaltej Road, Ahmedabad - 380054
Phone: 079 - 27454537 Fax: 079 - 27452006
www.sangath.org e-mail: vsc@sangath.org

1 THIRD FLOOR PLAN: FIRE FIGHTING

