


Single Line Diagram : Water Supply

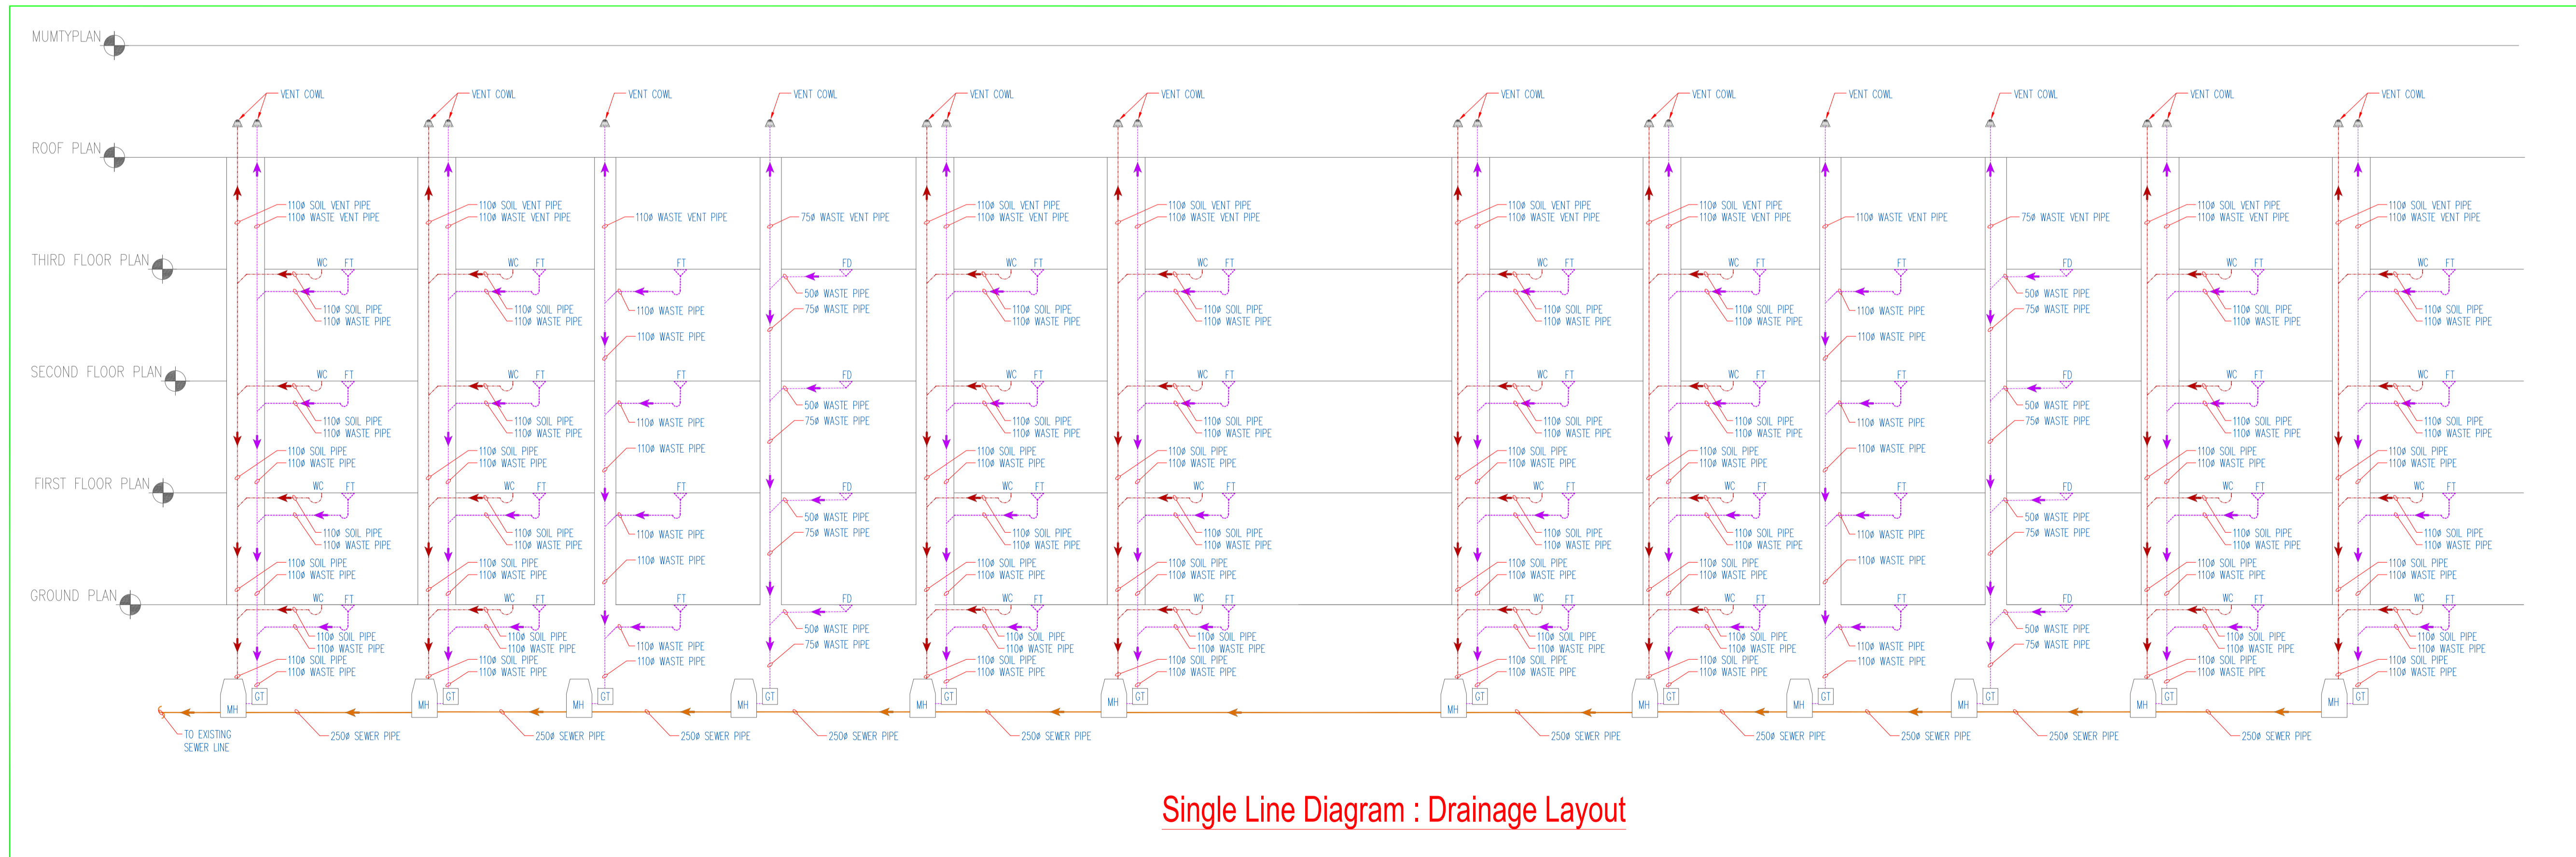

Single Line Diagram : Drainage Layout

1 Single Line Diagram : Plumbing

- NOTES
1. ALL DIMENSIONS SHALL BE CHECKED AND CO-RELATED WITH THE STRUCTURAL DRAWINGS AND ANY AMBIGUITY SHALL BE IMMEDIATELY BROUGHT TO THE NOTICE OF THE ARCHITECT BEFORE COMMENCEMENT OF THE WORK.
  2. ALL DIMENSIONS ARE IN CENTIMETERS UNLESS AND OTHERWISE SPECIFIED.
  3. ALL LEVELS ARE FINISHED LEVELS.
  4. ALL MARGINS, CLEARANCES ETC. REQUIRED AS PER BYE-LAWS SHOULD BE CHECKED AND PROVIDED BY THE CONTRACTOR. AND ANY DISCREPANCIES FOUND SHOULD BE IMMEDIATELY BROUGHT TO THE NOTICE OF ARCHITECT BEFORE COMMENCEMENT OF WORK.

LEGEND		
S.N.	DESCRIPTION	SYM.
1.	SP SOIL PIPE	
2.	WP WASTE PIPE	
3.	CWS COLD WATER SUPPLY	
4.	FWS FLUSHING W. SUPPLY	
5.	HWS HOT WATER SUPPLY	
6.	ROWS RO WATER SUPPLY	
7.	FWR FLUSHING WATER RISER	
8.	CWR COLD WATER RISER	
9.	FD FLOOR DRAIN	
10.	FT FLOOR TRAP	
11.	COP CLEAN OUT PLUG	
12.	FCO FLOOR CLEAN PLUG	
13.	RWP RAIN WATER PIPE	
14.	CB CATCH BASIN	
15.	MH MANHOLE	
16.	GT GULLY TRAP	

No.	Date.	Remarks.
Revisions		
Distribution of Prints		
Date	Prints	Issued to
Key Plan		
		N 

- Consultants
- Structural Consultants  
VR SHAH Consulting Engineers
  - Services Consultants  
dbHMS  
2nd Floor, D-82, Sector -2,  
Noida - 201301  
www.dbhms.in
  - Landscape Consultants  
Earthscaapes Consultancy Pvt Ltd
  - Road and Pathways Consultants  
Arhm Infra Consultants LLP

Project  
**Nalanda University, Rajgir, Bihar**

Title  
SINGLE LINE DIAGRAM - PLUMBING FOR TENDER

Dealt : JK  
Checked : AT  
Scale : NTS  
Date : 20-05-2016

Drawing No.  
NUC(1)-FAH-1B-P4.1  
Approved By :

**VASTU SHILPA CONSULTANTS**  
Architects | Planners | Urban Designers

"Sangath", Thaltej Road, Ahmedabad - 380054  
Phone: 079 - 27454537 Fax: 079 - 27452006  
www.sangath.org e-mail: vsc@sangath.org