


Y14
Y13
Y12
Y11
Y10
Y9
Y8
Y7
Y6
Y5
Y4
Y3
Y2
Y1

Y14
Y13
Y12
Y11
Y10
Y9
Y8
Y7
Y6
Y5
Y4
Y3
Y2
Y1

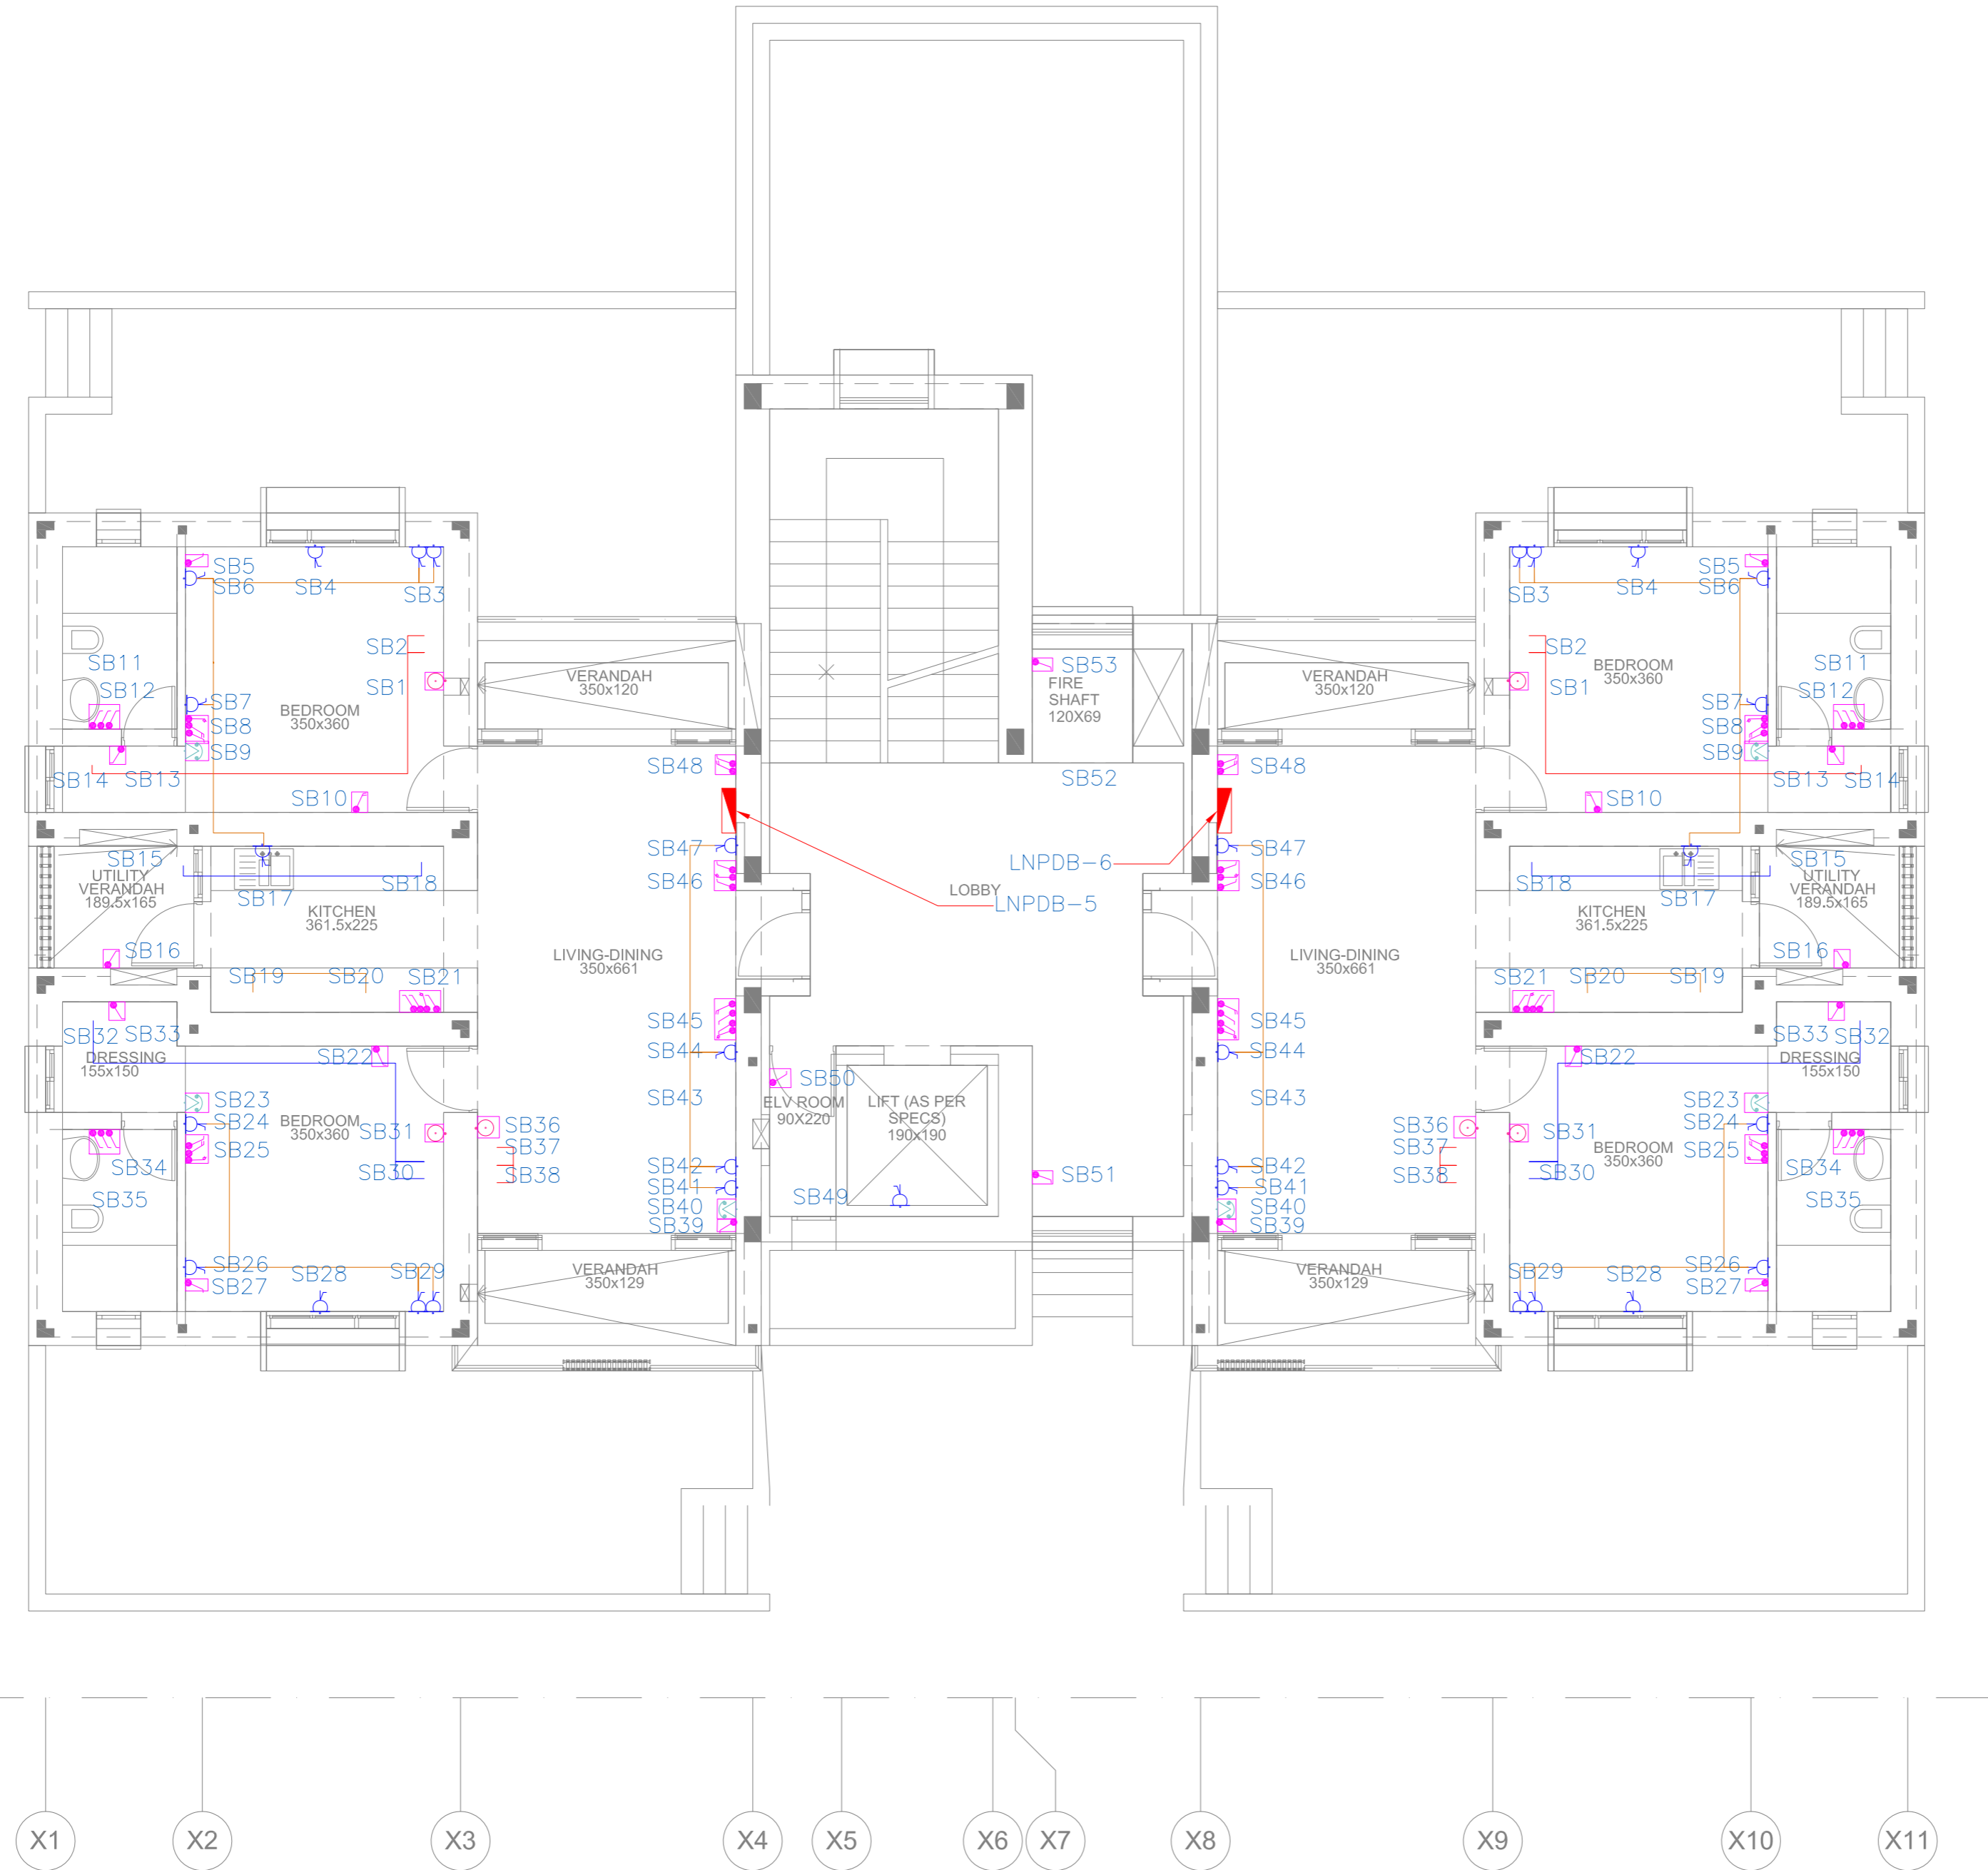

X1 X2 X3 X4 X5 X6 X7 X8 X9 X10 X11

4 SECOND FLOOR PLAN - ROUTING LAYOUT

- NOTES & INFORMATION**
1. ALL DIMENSIONS ARE INDICATED IN MILLIMETERS UNLESS OTHERWISE SPECIFIED.
 2. DIMENSIONS TO BE READ AND NOT MEASURED.
 3. ANY DISCREPANCY FOUND SHALL BE BROUGHT TO THE NOTICE OF THE ARCHITECTS / ENGINEERS.
 4. ALL DRAWINGS TO BE READ IN CONJUNCTION WITH RELEVANT STRUCTURAL, ARCHITECTURAL AND SERVICES DRAWINGS.

No.	Date	Remarks
Revisions		

Date	Prints	Issued to	Date	Prints	Issued to
Distribution of Prints					
Key Plan					

- Consultants**
- **Structural Consultants**
VR SHAH Consulting Engineers
 - **Services Consultants**
dbHMS
2nd Floor, D-62, Sector -2,
Noida - 201301
www.dbhms.in
 - **Landscape Consultants**
Earthscapes Consultancy Pvt Ltd
 - **Road and Pathways Consultants**
Arhmm Infra Consultants LLP

Project
Nalanda University, Rajgir, Bihar

Title
SECOND FLOOR PLAN - ROUTING LAYOUT FOR TENDER

Dealt : V.K	Drawing No.
Checked : M.T	NUC(1)-FAH-T3-E2.3.4
Scale : 1:50	Approved By : V.M.
Date : 03.06.2016	

VASTU SHILPA CONSULTANTS
Architects | Planners | Urban Designers

'Sangath', Thaltej Road, Ahmedabad - 380054
Phone: 079 - 27454537 Fax: 079 - 27452006
www.sangath.org e-mail: vsc@sangath.org