



LEGEND		
S.No	SYMBOL	DESCRIPTION
1.	◉	9LTR WATER CO ₂ FIRE EXTINGUISHER
2.	▶	2KG DRY POWDER FIRE EXTINGUISHER
3.	◉	FIRE HOSE REEL
4.	⊠	BUTTERFLY VALVE

NOTES & INFORMATION


- ALL DIMENSIONS ARE INDICATED IN MILLIMETERS UNLESS OTHERWISE SPECIFIED.
- DIMENSIONS TO BE READ AND NOT MEASURED.
- ANY DISCREPANCY FOUND SHALL BE BROUGHT TO THE NOTICE OF THE ARCHITECTS / ENGINEERS.
- ALL DRAWINGS TO BE READ IN CONJUNCTION WITH RELEVANT STRUCTURAL, ARCHITECTURAL AND SERVICES DRAWINGS.

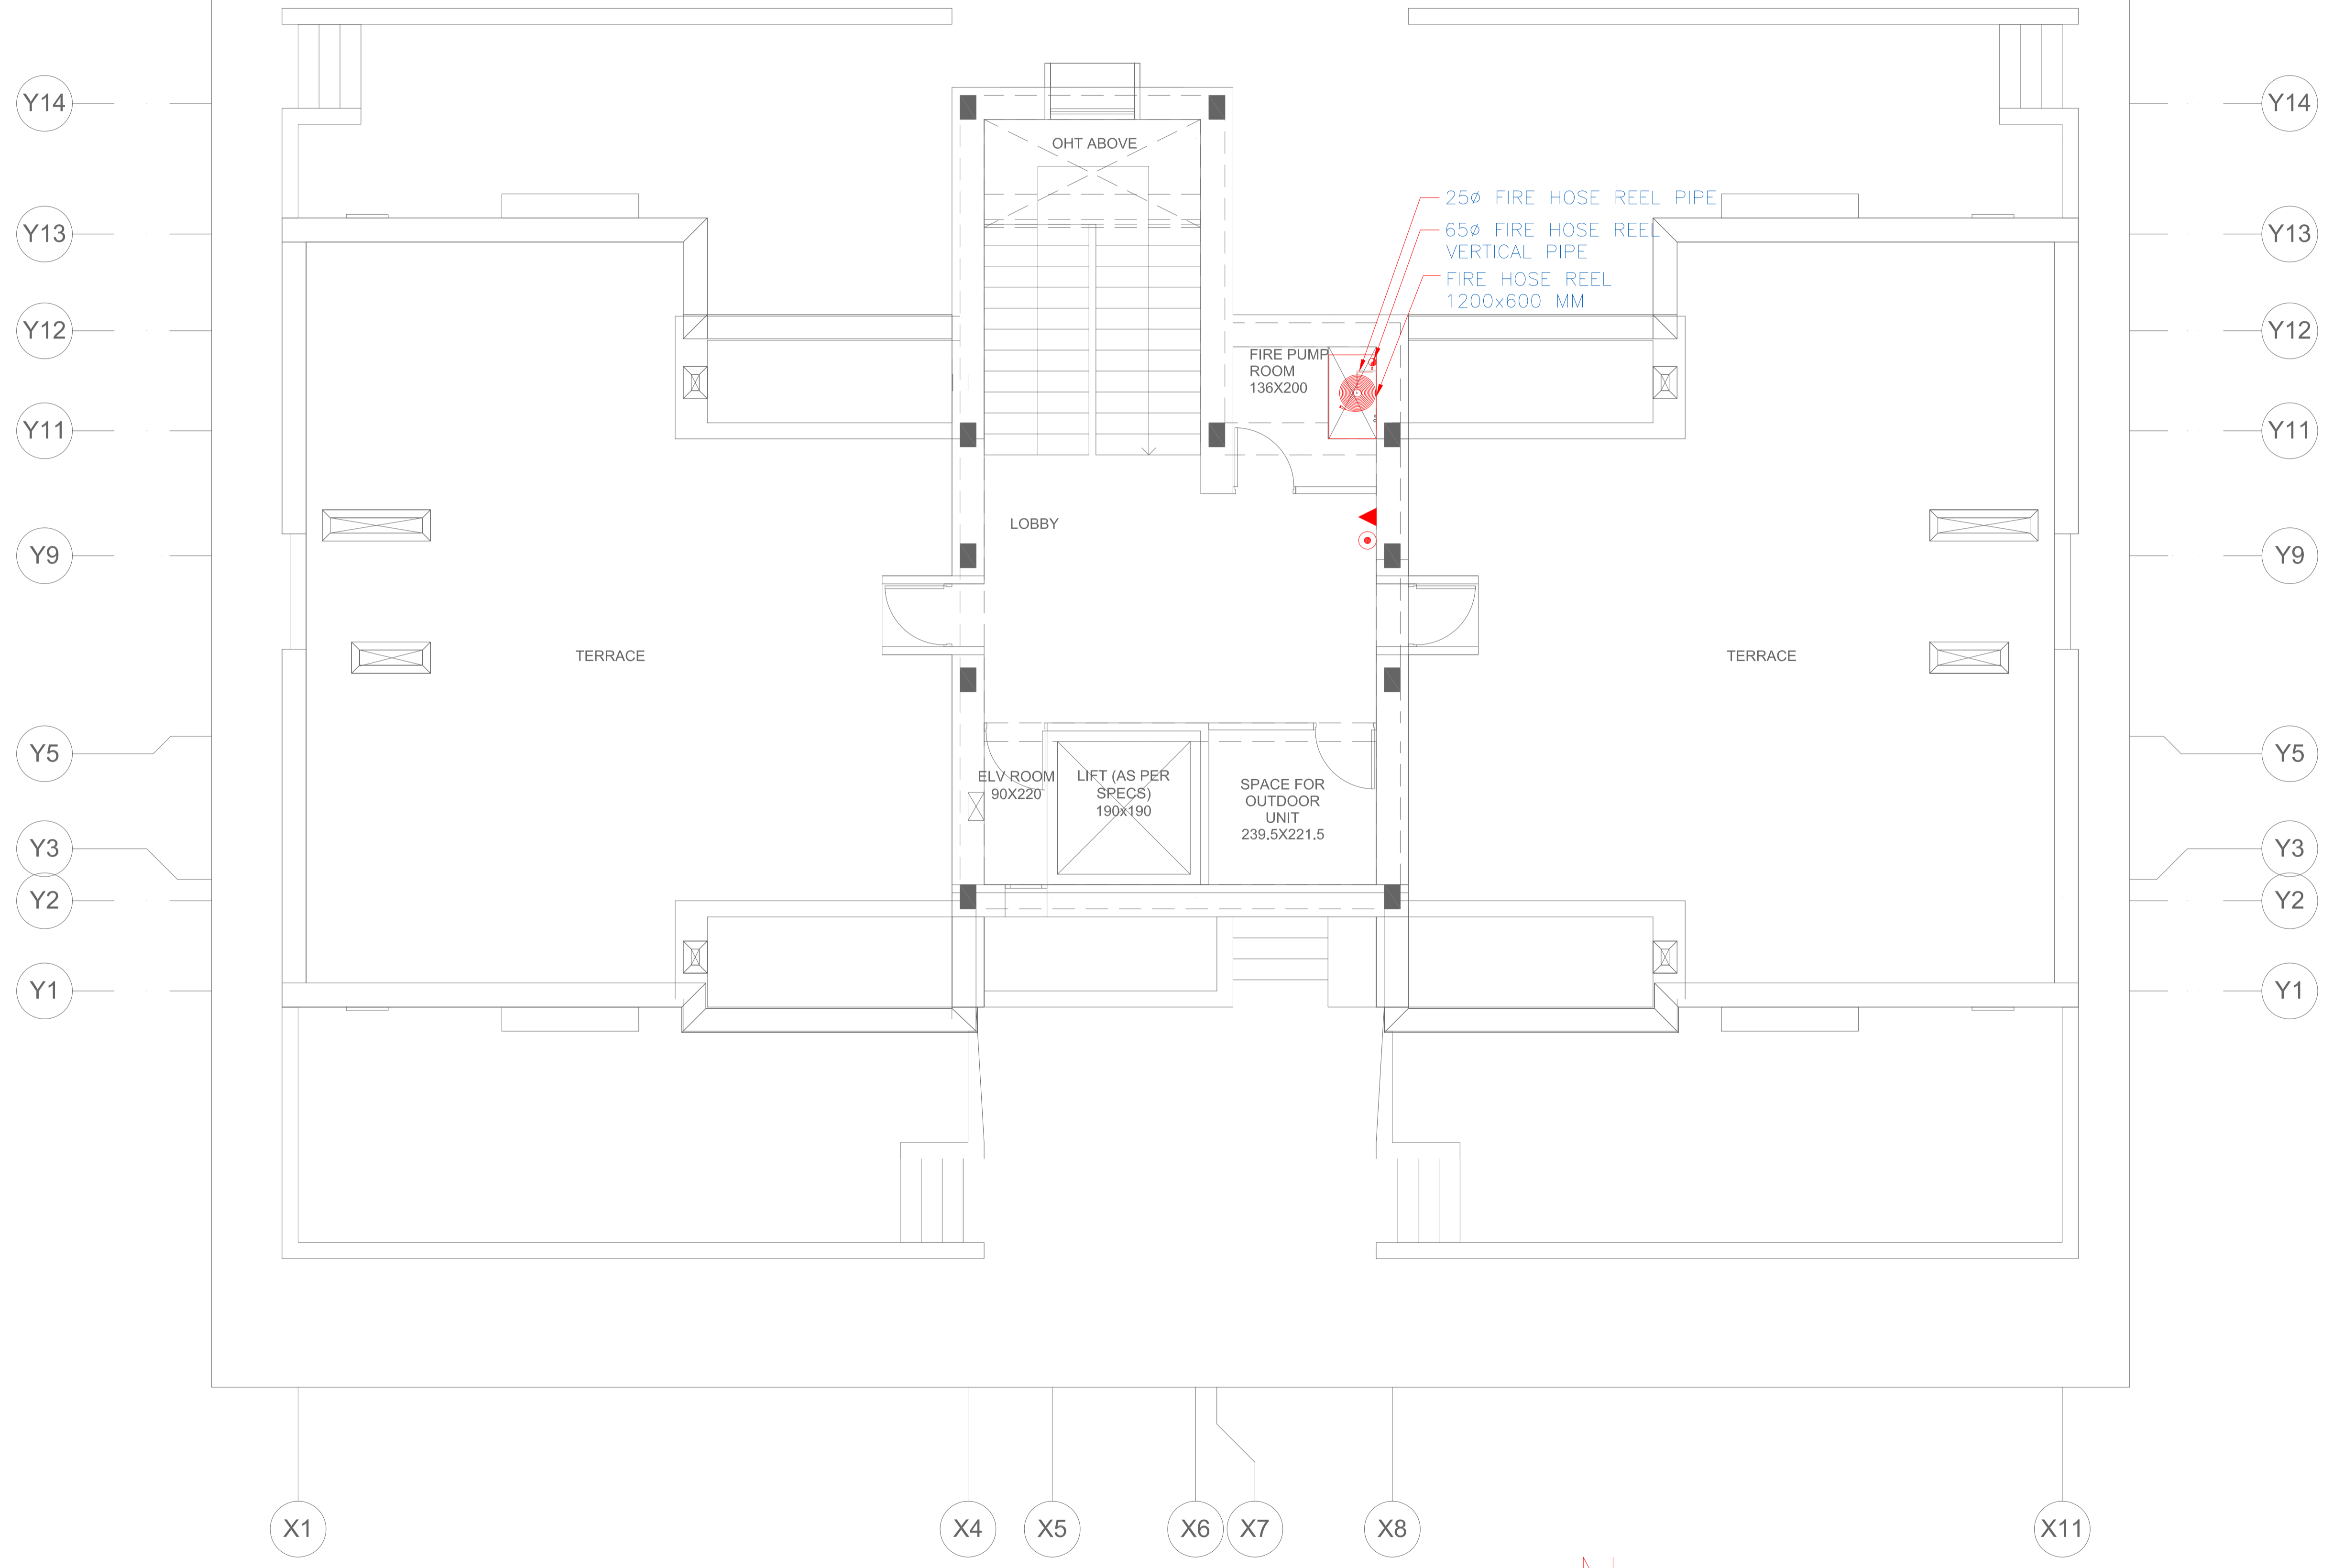

1 ROOF PLAN - FIRE FIGHTING

No.	Date.	Remarks.		
Revisions				
Date	Prints Issued to	Date	Prints	Issued to
Distribution of Prints				
Key Plan				
				

Consultants

- Structural Consultants
VR SHAH Consulting Engineers
- Services Consultants
 dbHMS
2nd Floor, D-62, Sector -2,
Noida - 201301
www.dbhms.in
- Landscape Consultants
Earthscape Consultancy Pvt Ltd
- Road and Pathways Consultants
Arhmm Infra Consultants LLP

Project
Nalanda University, Rajgir, Bihar

Title
ROOF PLAN - FIRE FIGHTING

FOR TENDER

Dealt : JK	Drawing No.
Checked : AT	NUC(1)-FAH-13-FF2.5
Scale : 1:50	
Date : 20.06.2016	Approved By : VM

VASTU SHILPA CONSULTANTS
Architects | Planners | Urban Designers

Sangath, Thaltej Road, Ahmedabad - 380054
Phone: 079 - 27454537 Fax: 079 - 27452006
www.sangath.org e-mail: vsc@sangath.org