


Single Line Diagram : Water Supply

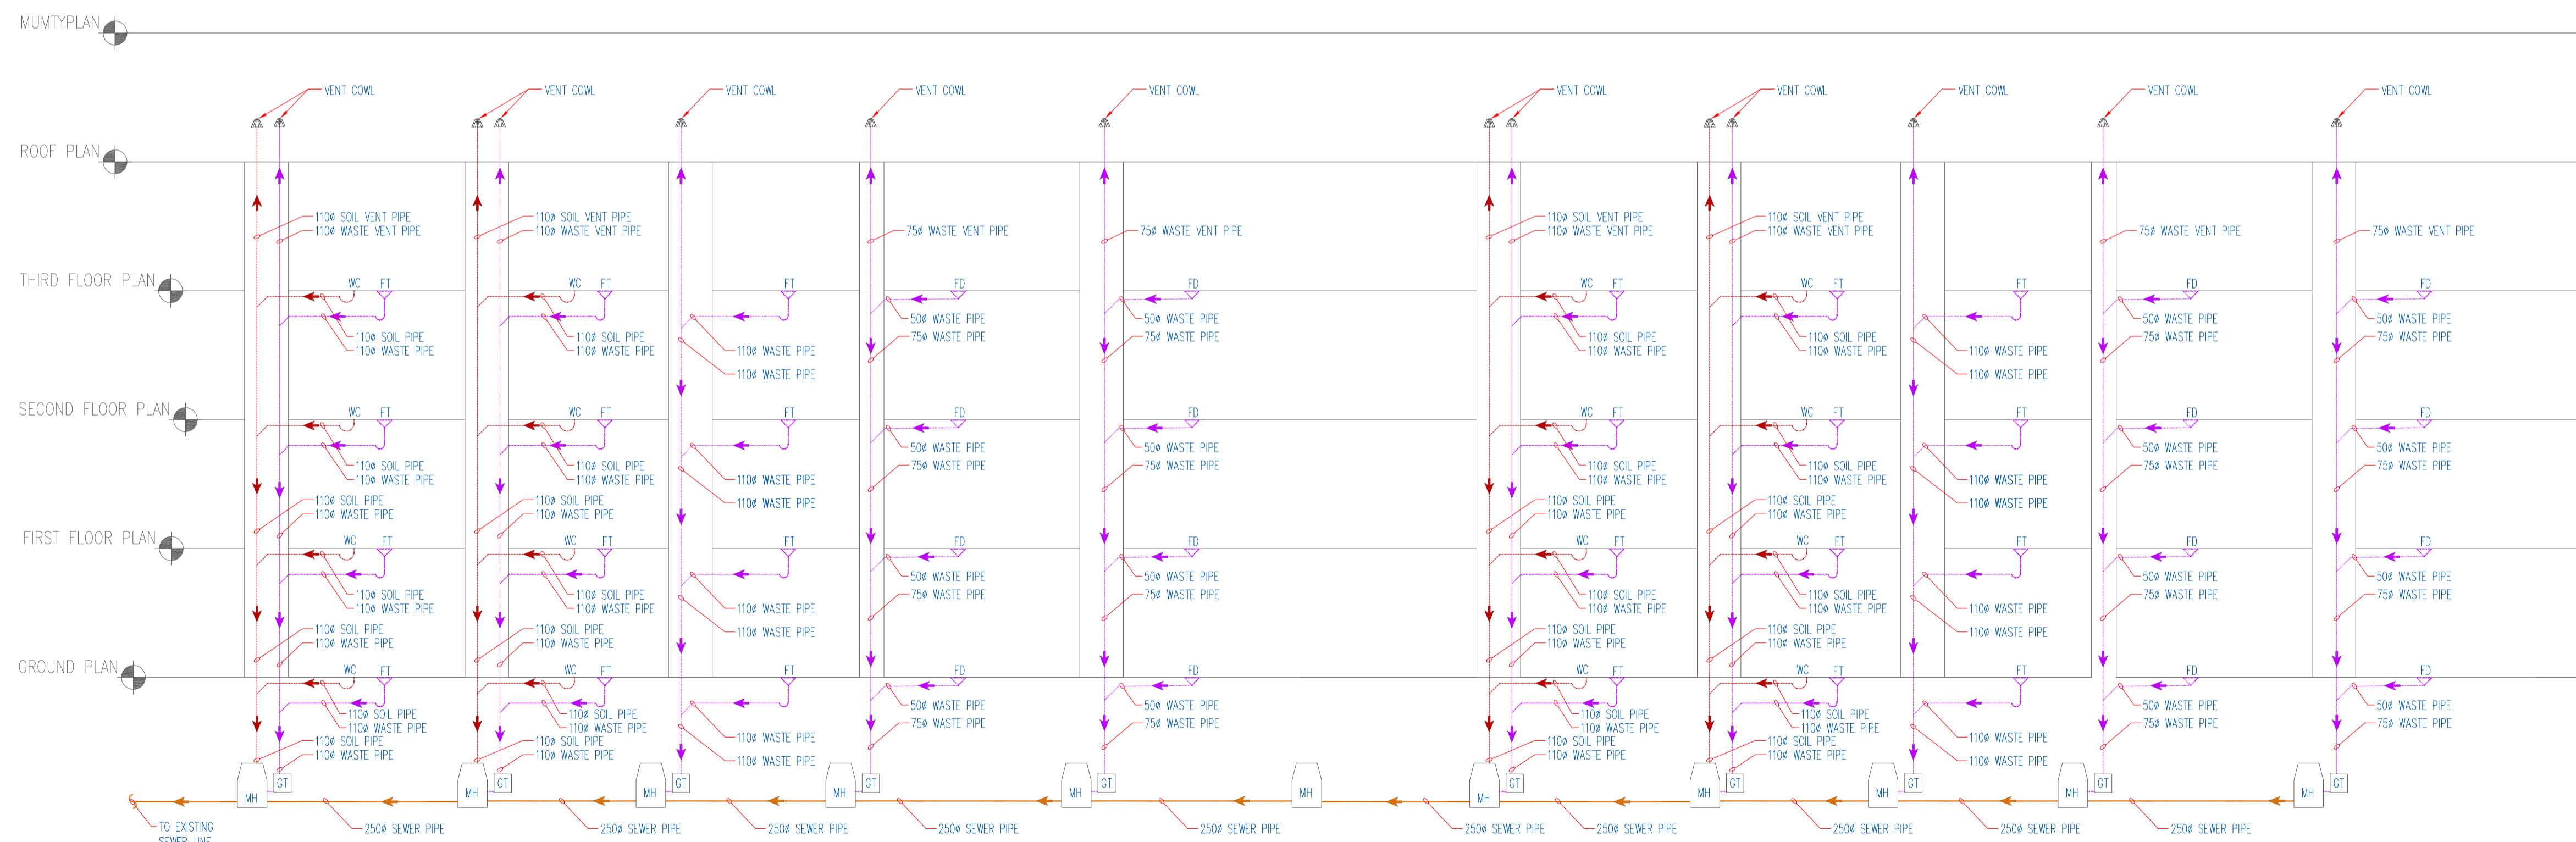

Single Line Diagram : Drainage Layout

1 Single Line Diagram : Plumbing

NOTES & INFORMATION

1. ALL DIMENSIONS ARE INDICATED IN MILLIMETERS UNLESS OTHERWISE SPECIFIED.
2. DIMENSIONS TO BE READ AND NOT MEASURED.
3. ANY DISCREPANCY FOUND SHALL BE BROUGHT TO THE NOTICE OF THE ARCHITECTS / ENGINEERS.
4. ALL DRAWINGS TO BE READ IN CONJUNCTION WITH RELEVANT STRUCTURAL, ARCHITECTURAL AND SERVICES DRAWINGS.

LEGEND		
S.N.	DESCRIPTION	SYM.
1.	SP	SOIL PIPE
2.	WP	WASTE PIPE
3.	CWS	COLD WATER SUPPLY
4.	FWS	FLUSHING W. SUPPLY
5.	HWS	HOT WATER SUPPLY
6.	ROWS	RO WATER SUPPLY
7.	FWR	FLUSHING WATER RISER
8.	CWR	COLD WATER RISER
9.	FD	FLOOR DRAIN
10.	FT	FLOOR TRAP
11.	COP	CLEAN OUT PLUG
12.	FCO	FLOOR CLEAN PLUG
13.	RWP	RAIN WATER PIPE
14.	CB	CATCH BASIN
15.	MH	MANHOLE
16.	GT	GULLY TRAP

No.	Date.	Remarks.
Revisions		

Date	Prints	Issued to	Date	Prints	Issued to
Distribution of Prints					
Key Plan					

- Consultants
- Structural Consultants
VR SHAH Consulting Engineers
 - Services Consultants
dbHMS
2nd Floor, D-62, Sector -2,
Noida - 201301
www.dbhms.in
 - Landscape Consultants
Earthscapes Consultancy Pvt Ltd
 - Road and Pathways Consultants
Arhmm Infra Consultants LLP

Project
Nalanda University, Rajgir, Bihar

Title
SINGLE LINE DIAGRAM – PLUMBING FOR TENDER

Dealt : JK	Drawing No.
Checked : AT	NUC(1)-FAH-T3-P4.1
Scale : NTS	
Date : 20-05-2016	Approved By: VM

VASTU SHILPA CONSULTANTS
Architects | Planners | Urban Designers

'Sangath', Thaltej Road, Ahmedabad - 380054
Phone: 079 - 27454537 Fax: 079 - 27452006
www.sangath.org e-mail: vsc@sangath.org