


PLUMBING LEGEND :-		LEGEND	
S.NO.	DESCRIPTION	SYMBOL	
1.	DOMESTIC WATER PIPE		
2.	FLUSHING WATER PIPE		
3.	DRINKING WATER PIPE		
4.	ESR WATER FILLING PIPE		
5.	SOIL PIPE		
6.	WASTE PIPE		
7.	RAIN WATER PIPE		
8.	SEWER PIPE LINE		
9.	STORM PIPE LINE		
10.	GULLY TRAP (GT)		
11.	SEWER MANHOLE		
12.	STORM MANHOLE		


- NOTES**
1. ALL DIMENSIONS SHALL BE CHECKED AND CO-RELATED WITH THE STRUCTURAL DRAWINGS AND ANY AMBIGUITY SHALL BE IMMEDIATELY BROUGHT TO THE NOTICE OF THE ARCHITECT BEFORE COMMENCEMENT OF THE WORK.
 2. ALL DIMENSIONS ARE IN CENTIMETERS UNLESS AND OTHERWISE SPECIFIED
 3. ALL LEVELS ARE FINISHED LEVELS.
 4. ALL MARGINS, CLEARANCES ETC. REQUIRED AS PER BYE-LAWS SHOULD BE CHECKED AND PROVIDED BY THE CONTRACTOR AND ANY DISCREPANCIES FOUND SHOULD BE IMMEDIATELY BROUGHT TO THE ATTENTION OF THE ARCHITECT BEFORE COMMENCEMENT OF WORK.
 5. FOR DETAILS OF ALL CUTOUTS IN SLABS AND BEAMS REFER SPECIFIC CONSULTANTS DRAWINGS.

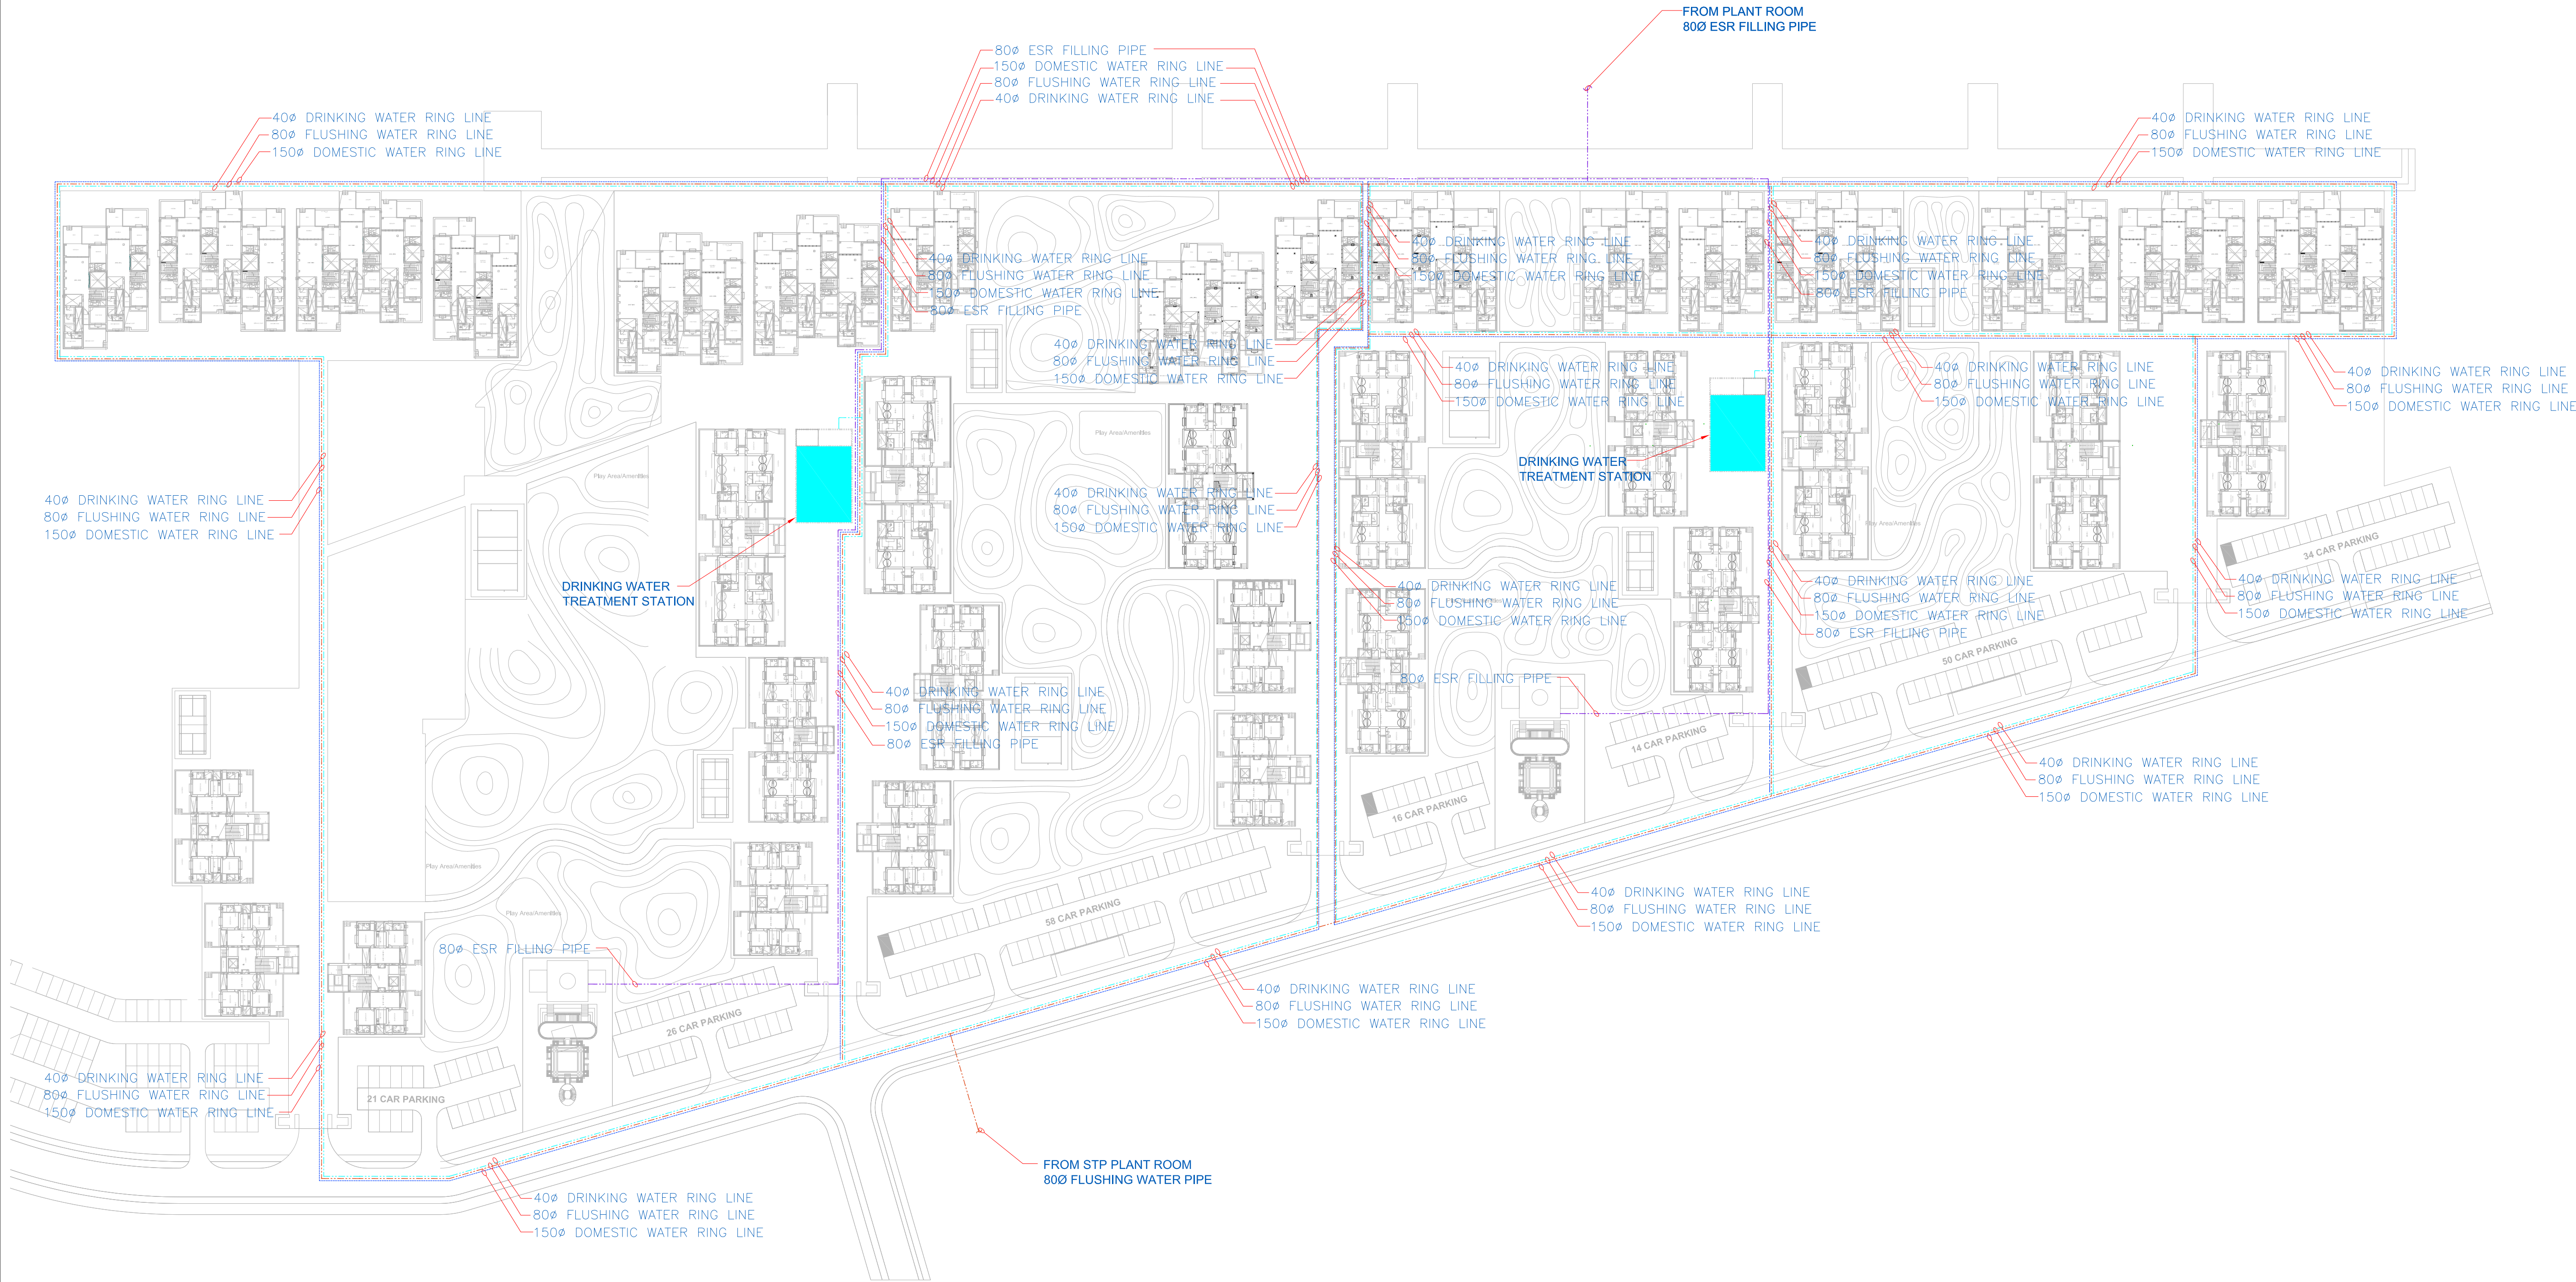

No.	Date.	Remarks.
Revisions		

Date	Prints	Issued to	Date	Prints	Issued to
------	--------	-----------	------	--------	-----------

 Distribution of Prints



Consultants

- **Structural Consultants**
VR SHAH Consulting Engineers

- **Services Consultants**
-  **dbHMS**
2nd Floor, D-62, Sector -2,
Noida - 201301
www.dbhms.in

- **Landscape Consultants**
Earthscapes Consultancy Pvt Ltd

- **Road and Pathways Consultants**
Arhmm Infra Consultants LLP

Project

Nalanda University, Rajgir, Bihar

Title

OVERALL PLAN –
WATER SUPPLY LAYOUT
FOR TENDER

Dealt :	JK	Drawing No.
Checked :	AT	NUC(1)-FRH-P2.3
Scale :	1:750	
Date :	20.09.2016	

VASTU SHILPA CONSULTANTS
Architects | Planners | Urban Designers

'Sangath', Thaltej Road, Ahmedabad - 380054
Phone: 079 - 27454537 Fax: 079 - 27452006
www.sangath.org e-mail: **vsc@sangath.org**