


LEGEND		
S.No	SYMBOL	DESCRIPTION
1.		9LTR WATER CO <sub>2</sub> FIRE EXTINGUISHER
2.		2KG DRY POWDER FIRE EXTINGUISHER
3.		FIRE HOSE REEL
4.		BALL VALVE

- NOTES**
- ALL DIMENSIONS SHALL BE CHECKED AND CO-RELATED WITH THE STRUCTURAL DRAWINGS AND ANY AMBIGUITY SHALL BE IMMEDIATELY BROUGHT TO THE NOTICE OF THE ARCHITECT BEFORE COMMENCEMENT OF THE WORK.
  - ALL DIMENSIONS ARE IN CENTIMETERS UNLESS AND OTHERWISE SPECIFIED
  - ALL LEVELS ARE FINISHED LEVELS.
  - ALL MARGINS, CLEARANCES ETC. REQUIRED AS PER BYE-LAWS SHOULD BE CHECKED AND PROVIDED BY THE CONTRACTOR AND ANY DISCREPANCIES FOUND SHOULD BE IMMEDIATELY BROUGHT TO THE NOTICE OF ARCHITECT BEFORE COMMENCEMENT OF WORK.
  - FOR DETAILS OF ALL CUTOUTS IN SLABS AND BEAMS REFER SERVICES CONSULTANTS DRAWINGS.
  - FOR STAIRCASE DETAILS REFER DRAWING NO. 5.1
  - FOR TOILET DETAILS REFER DRAWING NO. 6.1
  - FOR DOOR DETAILS REFER DRWG NO. 8.1
  - FOR WINDOW DETAILS REFER DRWG NO. 9.1
  - FOR KITCHEN - PANTRY DETAILS REFER DRWG NO. 10.1
  - FOR MISCELLANEOUS DETAILS REFER DRAWING NO. 29.1
  - FOR VERANDAH DETAILS REFER DRAWING NO. 31.1

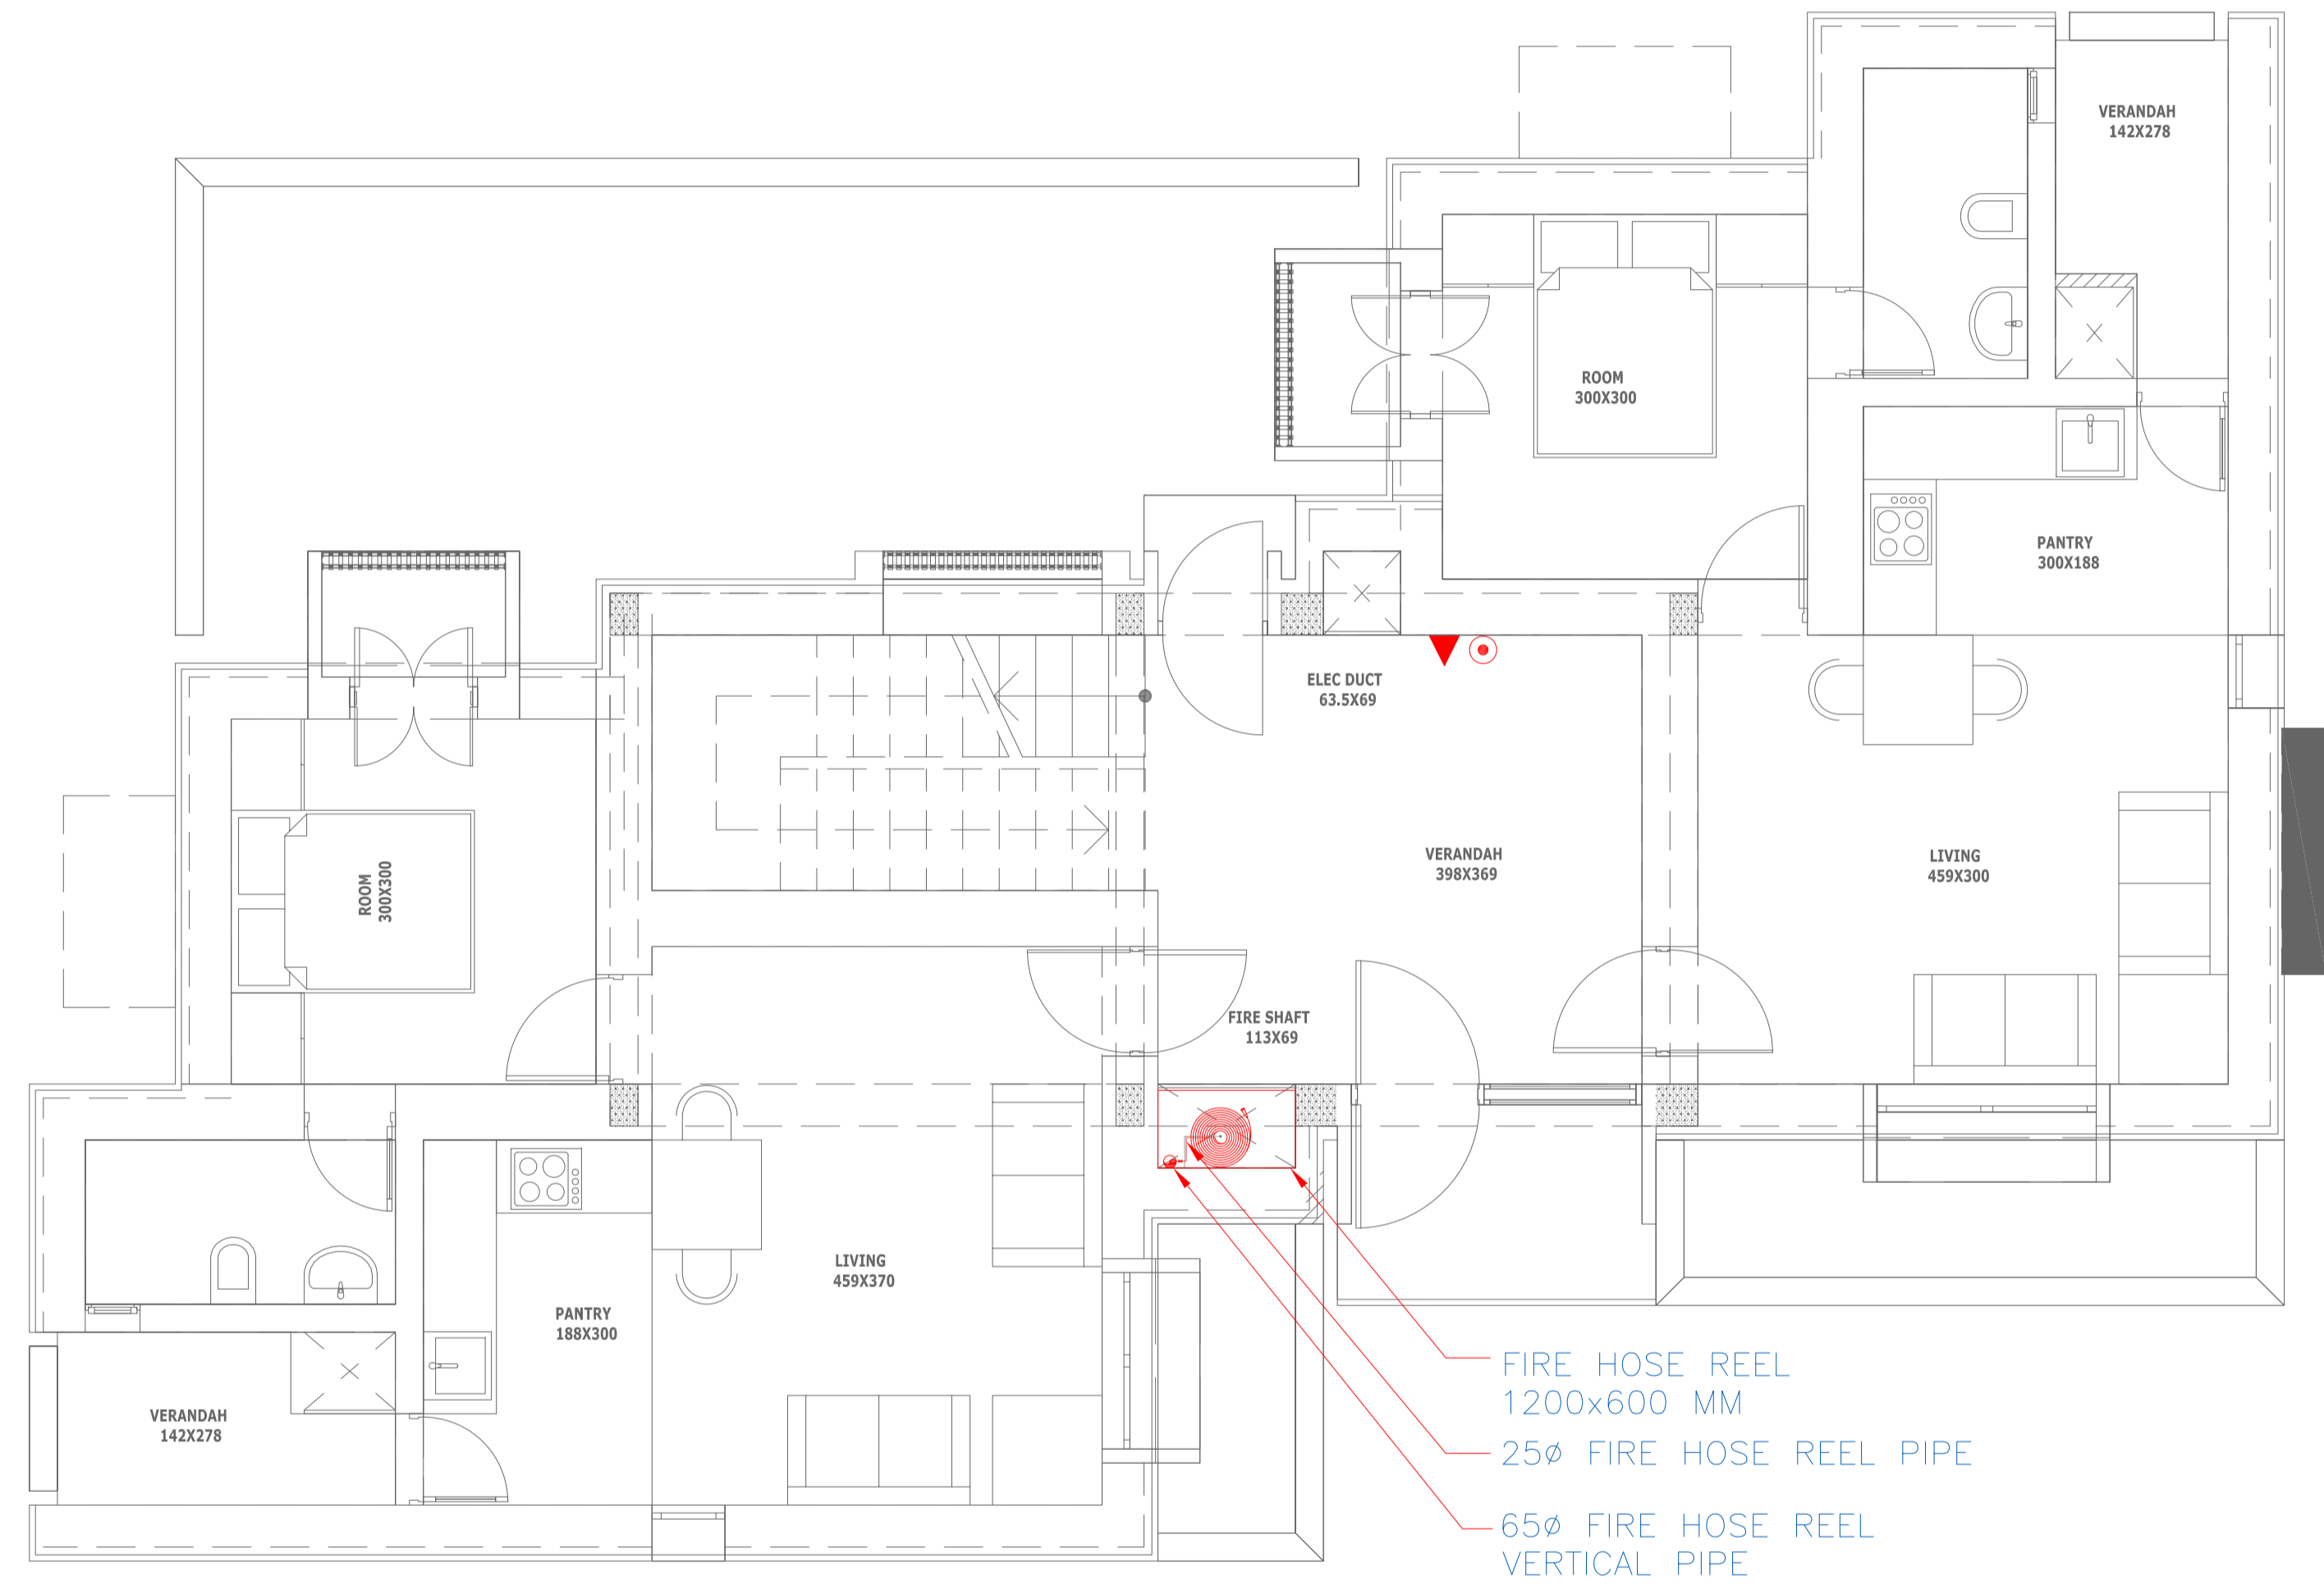


FIRE HOSE REEL  
1200x600 MM  
25 $\phi$  FIRE HOSE REEL PIPE  
65 $\phi$  FIRE HOSE REEL  
VERTICAL PIPE

No.	Date.	Remarks.
Revisions		

Date	Prints	Issued to	Date	Prints	Issued to
Distribution of Prints					



- Consultants**
- Structural Consultants**  
VR SHAH Consulting Engineers
  - Services Consultants**  
 dbHMS  
2nd Floor, D-62, Sector -2,  
Noida - 201301  
www.dbhms.in
  - Landscape Consultants**  
Earthscapes Consultancy Pvt Ltd
  - Road and Pathways Consultants**  
Arhmm Infra Consultants LLP

**Project**  
Nalanda University, Rajgir, Bihar

**Title**  
GROUND FLOOR PLAN –  
FIRE FIGHTING  
FOR TENDER

Dealt : JK	Drawing No.
Checked : AT	NUC(1)-MSH-FF2.1
Scale : 1:50	Aprd By : VM
Date : 20.05.2016	

**VASTU SHILPA CONSULTANTS**  
Architects | Planners | Urban Designers

\*Sangath\*, Thaltej Road, Ahmedabad - 380054  
Phone: 079 - 27454537 Fax: 079 - 27452006  
www.sangath.org e-mail: vsc@sangath.org

# 1 GROUND FLOOR PLAN - FIRE FIGHTING