


LEGEND		
S.No	SYMBOL	DESCRIPTION
1.		9LTR WATER CO ₂ FIRE EXTINGUISHER
2.		2KG DRY POWDER FIRE EXTINGUISHER
3.		FIRE HOSE REEL
4.		BALL VALVE

- NOTES**
1. ALL DIMENSIONS SHALL BE CHECKED AND CO-RELATED WITH THE STRUCTURAL DRAWINGS AND ANY AMBIGUITY SHALL BE IMMEDIATELY BROUGHT TO THE NOTICE OF THE ARCHITECT BEFORE COMMENCEMENT OF THE WORK.
 2. ALL DIMENSIONS ARE IN CENTIMETERS UNLESS AND OTHERWISE SPECIFIED
 3. ALL LEVELS ARE FINISHED LEVELS.
 4. ALL MARGINS, CLEARANCES ETC. REQUIRED AS PER BYE-LAWS SHOULD BE CHECKED AND PROVIDED BY THE CONTRACTOR AND ANY DISCREPANCIES FOUND SHOULD BE IMMEDIATELY BROUGHT TO THE NOTICE OF ARCHITECT BEFORE COMMENCEMENT OF WORK.
 5. FOR DETAILS OF ALL CUTOUTS IN SLABS AND BEAMS REFER SERVICES CONSULTANTS DRAWINGS.
 6. FOR STAIRCASE DETAILS REFER DRAWING NO. 5.1
 7. FOR TOILET DETAILS REFER DRAWING NO. 6.1
 8. FOR DOOR DETAILS REFER DRWG NO. 8.1
 9. FOR WINDOW DETAILS REFER DRWG NO. 9.1
 10. FOR KITCHEN - PANTRY DETAILS REFER DRWG NO. 10.1
 11. FOR MISCELLANEOUS DETAILS REFER DRAWING NO. 29.1
 12. FOR VERANDAH DETAILS REFER DRAWING NO. 31.1

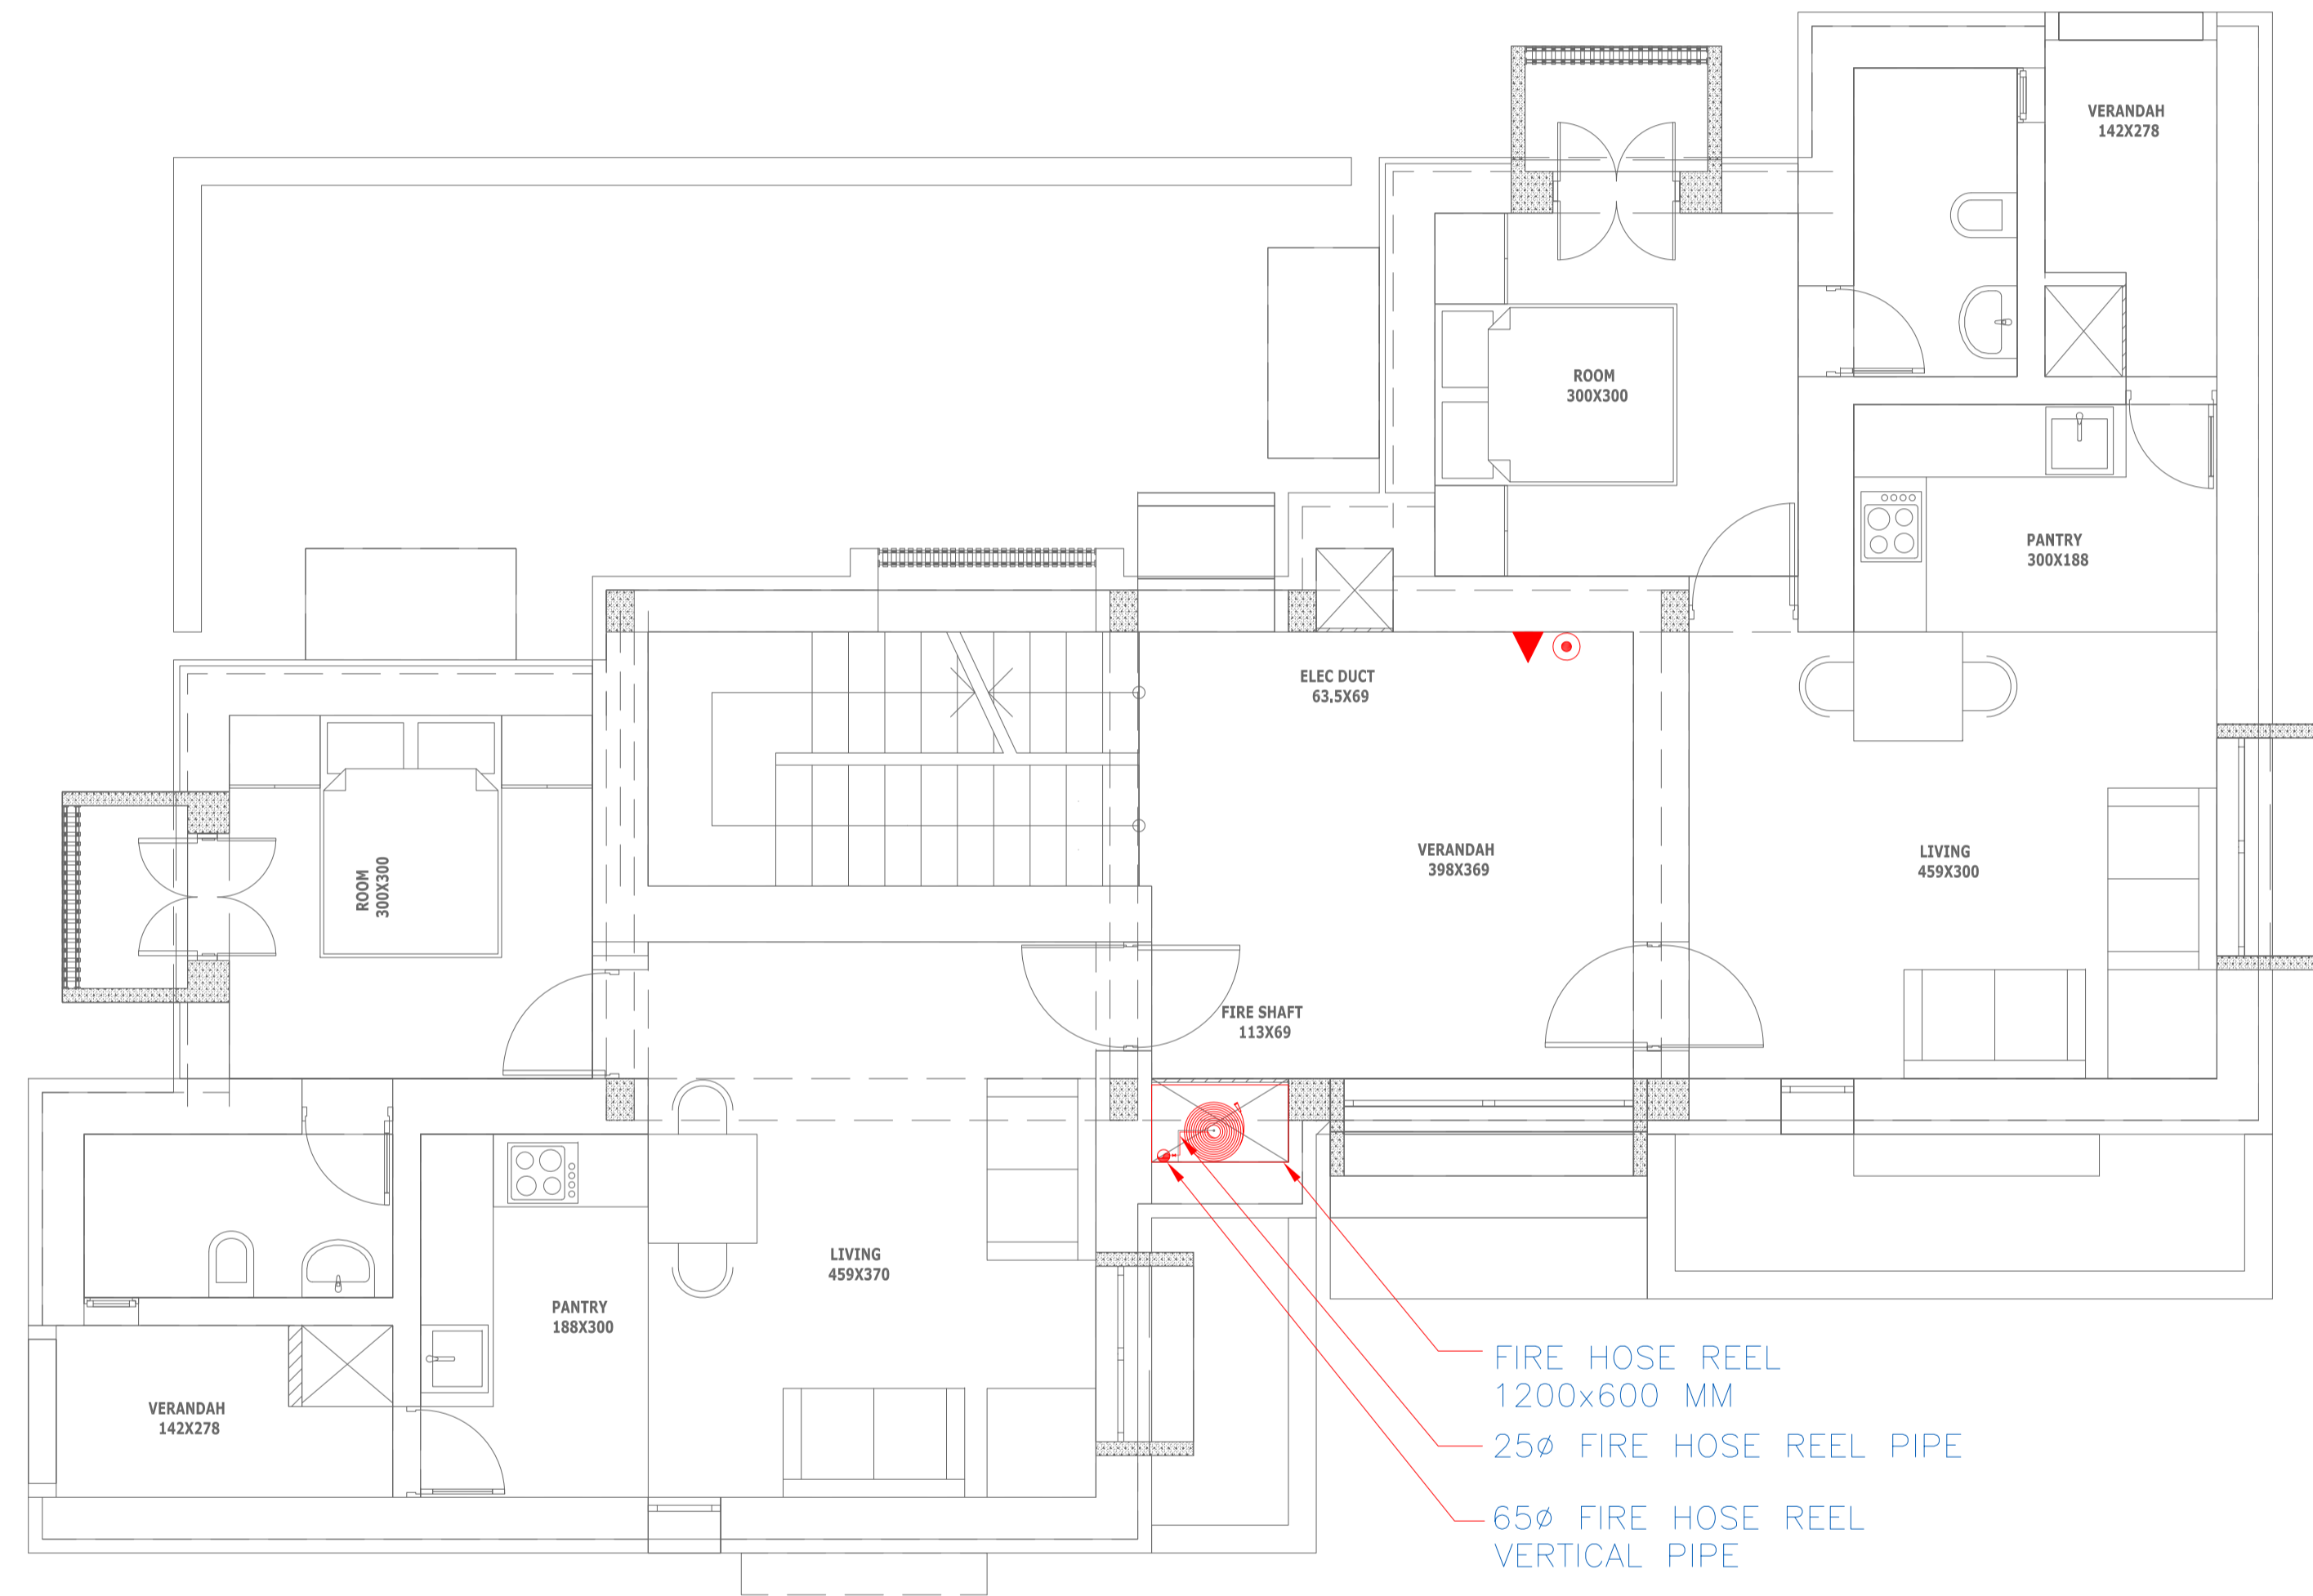


FIRE HOSE REEL
1200x600 MM
25 ϕ FIRE HOSE REEL PIPE
65 ϕ FIRE HOSE REEL
VERTICAL PIPE

No.	Date.	Remarks.
Revisions		

Date	Prints	Issued to	Date	Prints	Issued to
Distribution of Prints					

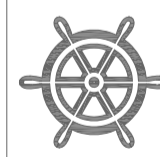

- Consultants**
- Structural Consultants**
VR SHAH Consulting Engineers
 - Services Consultants**
 dbHMS
2nd Floor, D-62, Sector -2,
Noida - 201301
www.dbhms.in
 - Landscape Consultants**
Earthscapes Consultancy Pvt Ltd
 - Road and Pathways Consultants**
Arhmm Infra Consultants LLP

Project
Nalanda University, Rajgir, Bihar

Title
FIRST FLOOR PLAN -
FIRE FIGHTING
FOR TENDER

Dealt : JK	Drawing No.
Checked : AT	NUC(1)-MSH-FF2.2
Scale : 1:50	Aprd By : VM
Date : 20.05.2016	

VASTU SHILPA CONSULTANTS
Architects | Planners | Urban Designers

Sangath, Thaltej Road, Ahmedabad - 380054
Phone: 079 - 27454537 Fax: 079 - 27452006
www.sangath.org e-mail: vsc@sangath.org

1 FIRST FLOOR PLAN - FIRE FIGHTING