


LEGEND		
S.No	SYMBOL	DESCRIPTION
1.		9LTR WATER CO ₂ FIRE EXTINGUISHER
2.		2KG DRY POWDER FIRE EXTINGUISHER
3.		FIRE HOSE REEL
4.		BUTTERFLY VALVE

- NOTES**
- ALL DIMENSIONS SHALL BE CHECKED AND CO-RELATED WITH THE STRUCTURAL DRAWINGS AND ANY AMBIGUITY SHALL BE IMMEDIATELY BROUGHT TO THE NOTICE OF THE ARCHITECT BEFORE COMMENCEMENT OF THE WORK.
 - ALL DIMENSIONS ARE IN CENTIMETERS UNLESS AND OTHERWISE SPECIFIED
 - ALL LEVELS ARE FINISHED LEVELS.
 - ALL MARGINS, CLEARANCES ETC. REQUIRED AS PER BYE-LAWS SHOULD BE CHECKED AND PROVIDED BY THE CONTRACTOR AND ANY DISCREPANCIES FOUND SHOULD BE IMMEDIATELY BROUGHT TO THE NOTICE OF ARCHITECT BEFORE COMMENCEMENT OF WORK.
 - FOR DETAILS OF ALL CUTOUTS IN SLABS AND BEAMS REFER SERVICES CONSULTANTS DRAWINGS.
 - FOR STAIRCASE DETAILS REFER DRAWING NO. 5.1
 - FOR TOILET DETAILS REFER DRAWING NO. 6.1
 - FOR DOOR DETAILS REFER DRWG NO. 8.1
 - FOR WINDOW DETAILS REFER DRWG NO. 9.1
 - FOR KITCHEN - PANTRY DETAILS REFER DRWG NO. 10.1
 - FOR MISCELLANEOUS DETAILS REFER DRAWING NO. 29.1
 - FOR VERANDAH DETAILS REFER DRAWING NO. 31.1

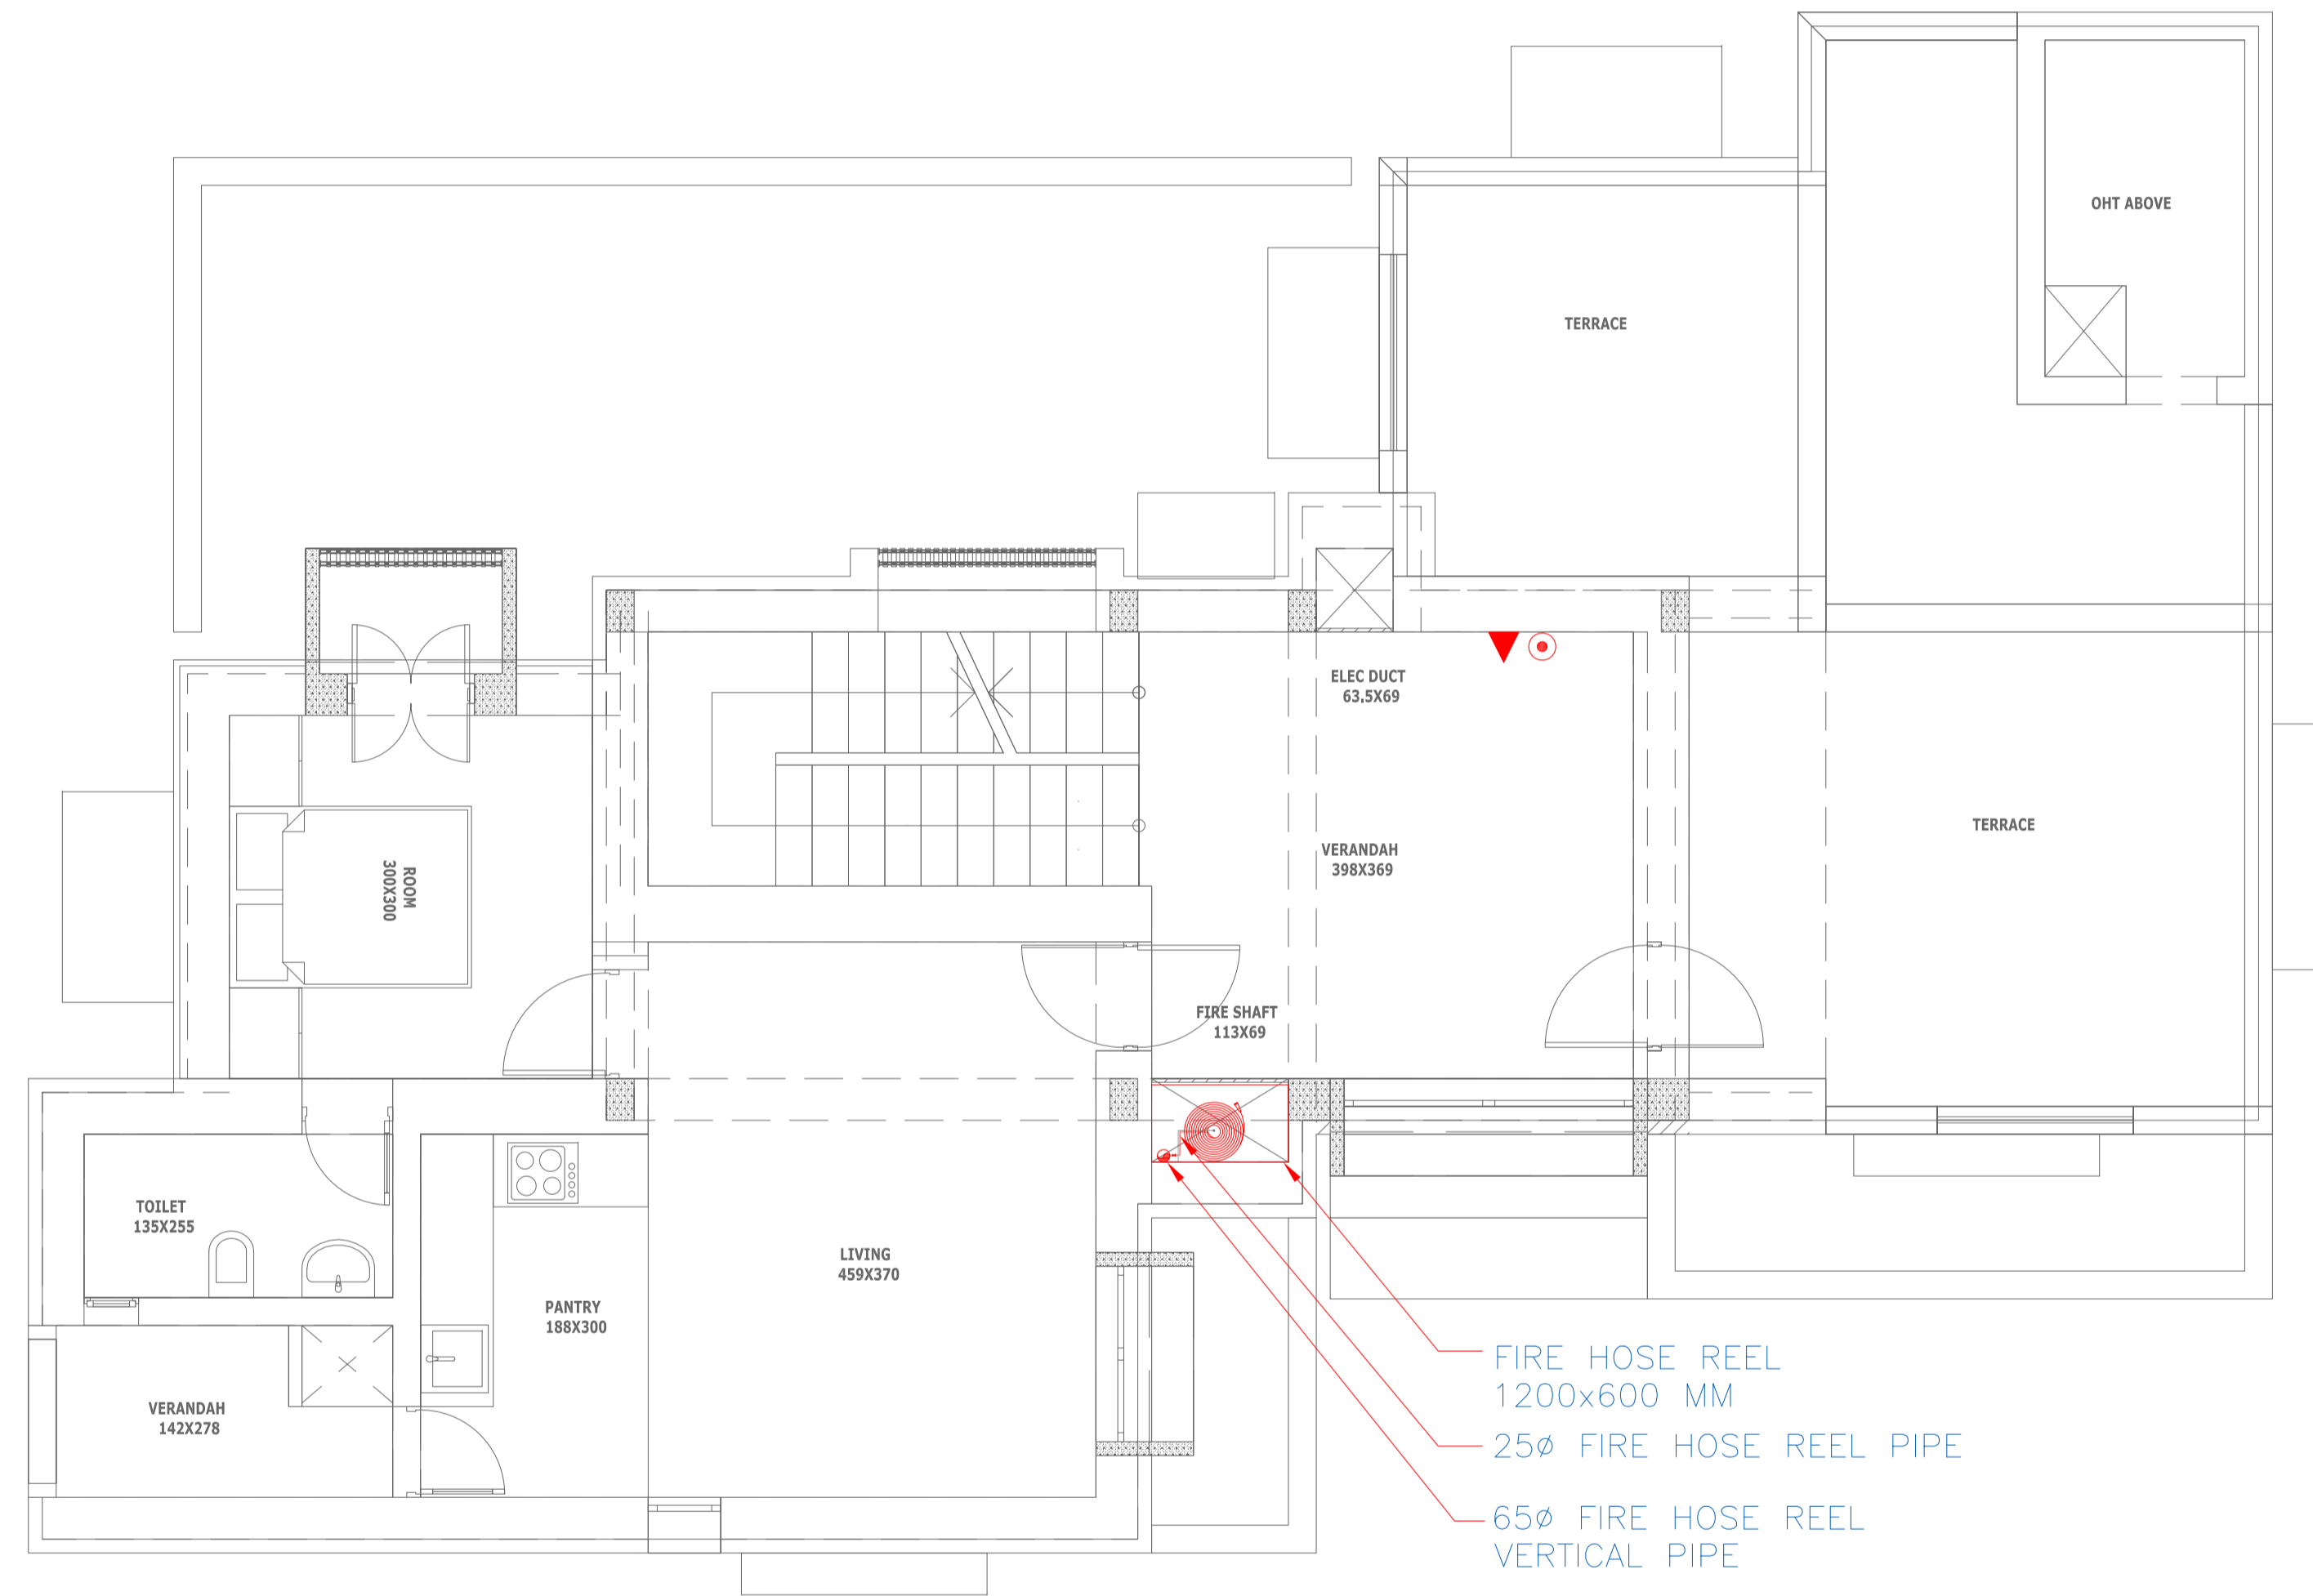

FIRE HOSE REEL
1200x600 MM
25 ϕ FIRE HOSE REEL PIPE
65 ϕ FIRE HOSE REEL
VERTICAL PIPE

No.	Date.	Remarks.
Revisions		

Date	Prints	Issued to	Date	Prints	Issued to
Distribution of Prints					



- Consultants**
- Structural Consultants**
VR SHAH Consulting Engineers
 - Services Consultants**
 dbHMS
2nd Floor, D-62, Sector -2,
Noida - 201301
www.dbhms.in
 - Landscape Consultants**
Earthscapes Consultancy Pvt Ltd
 - Road and Pathways Consultants**
Arhmm Infra Consultants LLP

Project
Nalanda University, Rajgir, Bihar

Title
THIRD FLOOR PLAN -
FIRE FIGHTING
FOR TENDER

Dealt : JK	Drawing No. NUC(1)-MSH-TD-FF2.4
Checked : AT	Aprd By : VM
Scale : 1:50	
Date : 20.05.2016	

VASTU SHILPA CONSULTANTS
Architects | Planners | Urban Designers

Sangath, Thaltej Road, Ahmedabad - 380054
Phone: 079 - 27454537 Fax: 079 - 27452006
www.sangath.org e-mail: vsc@sangath.org

1 THIRD FLOOR PLAN - FIRE FIGHTING