


- NOTES**
1. ALL DIMENSIONS SHALL BE CHECKED AND CO-RELATED WITH THE STRUCTURAL DRAWINGS AND ANY AMBIGUITY SHALL BE IMMEDIATELY BROUGHT TO THE NOTICE OF THE ARCHITECT BEFORE COMMENCEMENT OF THE WORK.
 2. ALL DIMENSIONS ARE IN CENTIMETERS UNLESS AND OTHERWISE SPECIFIED.
 3. ALL LEVELS ARE FINISHED LEVELS.
 4. ALL MARGINS, CLEARANCES ETC. REQUIRED AS PER BYE-LAWS SHOULD BE CHECKED AND PROVIDED BY THE CONTRACTOR AND ANY DISCREPANCIES FOUND SHOULD BE IMMEDIATELY BROUGHT TO THE NOTICE OF ARCHITECT BEFORE COMMENCEMENT OF WORK.
 5. FOR DETAILS OF ALL CUTOUTS IN SLABS AND BEAMS REFER SERVICES CONSULTANTS DRAWINGS.
 6. FOR STAIRCASE DETAILS REFER DRAWING NO. 5.1
 7. FOR TOILET DETAILS REFER DRAWING NO. 6.1
 8. FOR DOOR DETAILS REFER DRWG NO. 8.1
 9. FOR WINDOW DETAILS REFER DRWG NO. 9.1
 10. FOR KITCHEN - PANTRY DETAILS REFER DRWG NO. 10.1
 11. FOR MISCELLANEOUS DETAILS REFER DRAWING NO. 29.1
 12. FOR VERANDAH DETAILS REFER DRAWING NO. 31.1

LEGEND		
S.N.	DESCRIPTION	SYM.
1.	SP	SOIL PIPE
2.	WP	WASTE PIPE
3.	CWS	COLD WATER SUPPLY
4.	FWS	FLUSHING W. SUPPLY
5.	HWS	HOT WATER SUPPLY
6.	ROWS	RO WATER SUPPLY
7.	FWR	FLUSHING WATER RISER
8.	CWR	COLD WATER RISER
9.	HWR	HOT WATER RISER
10.	FD	FLOOR DRAIN
11.	FT	FLOOR TRAP
12.	COP	CLEAN OUT PLUG
13.	FCO	FLOOR CLEAN PLUG
14.	RWP	RAIN WATER PIPE
15.	CB	CATCH BASIN
16.	MH	MANHOLE
17.	GT	GULLY TRAP

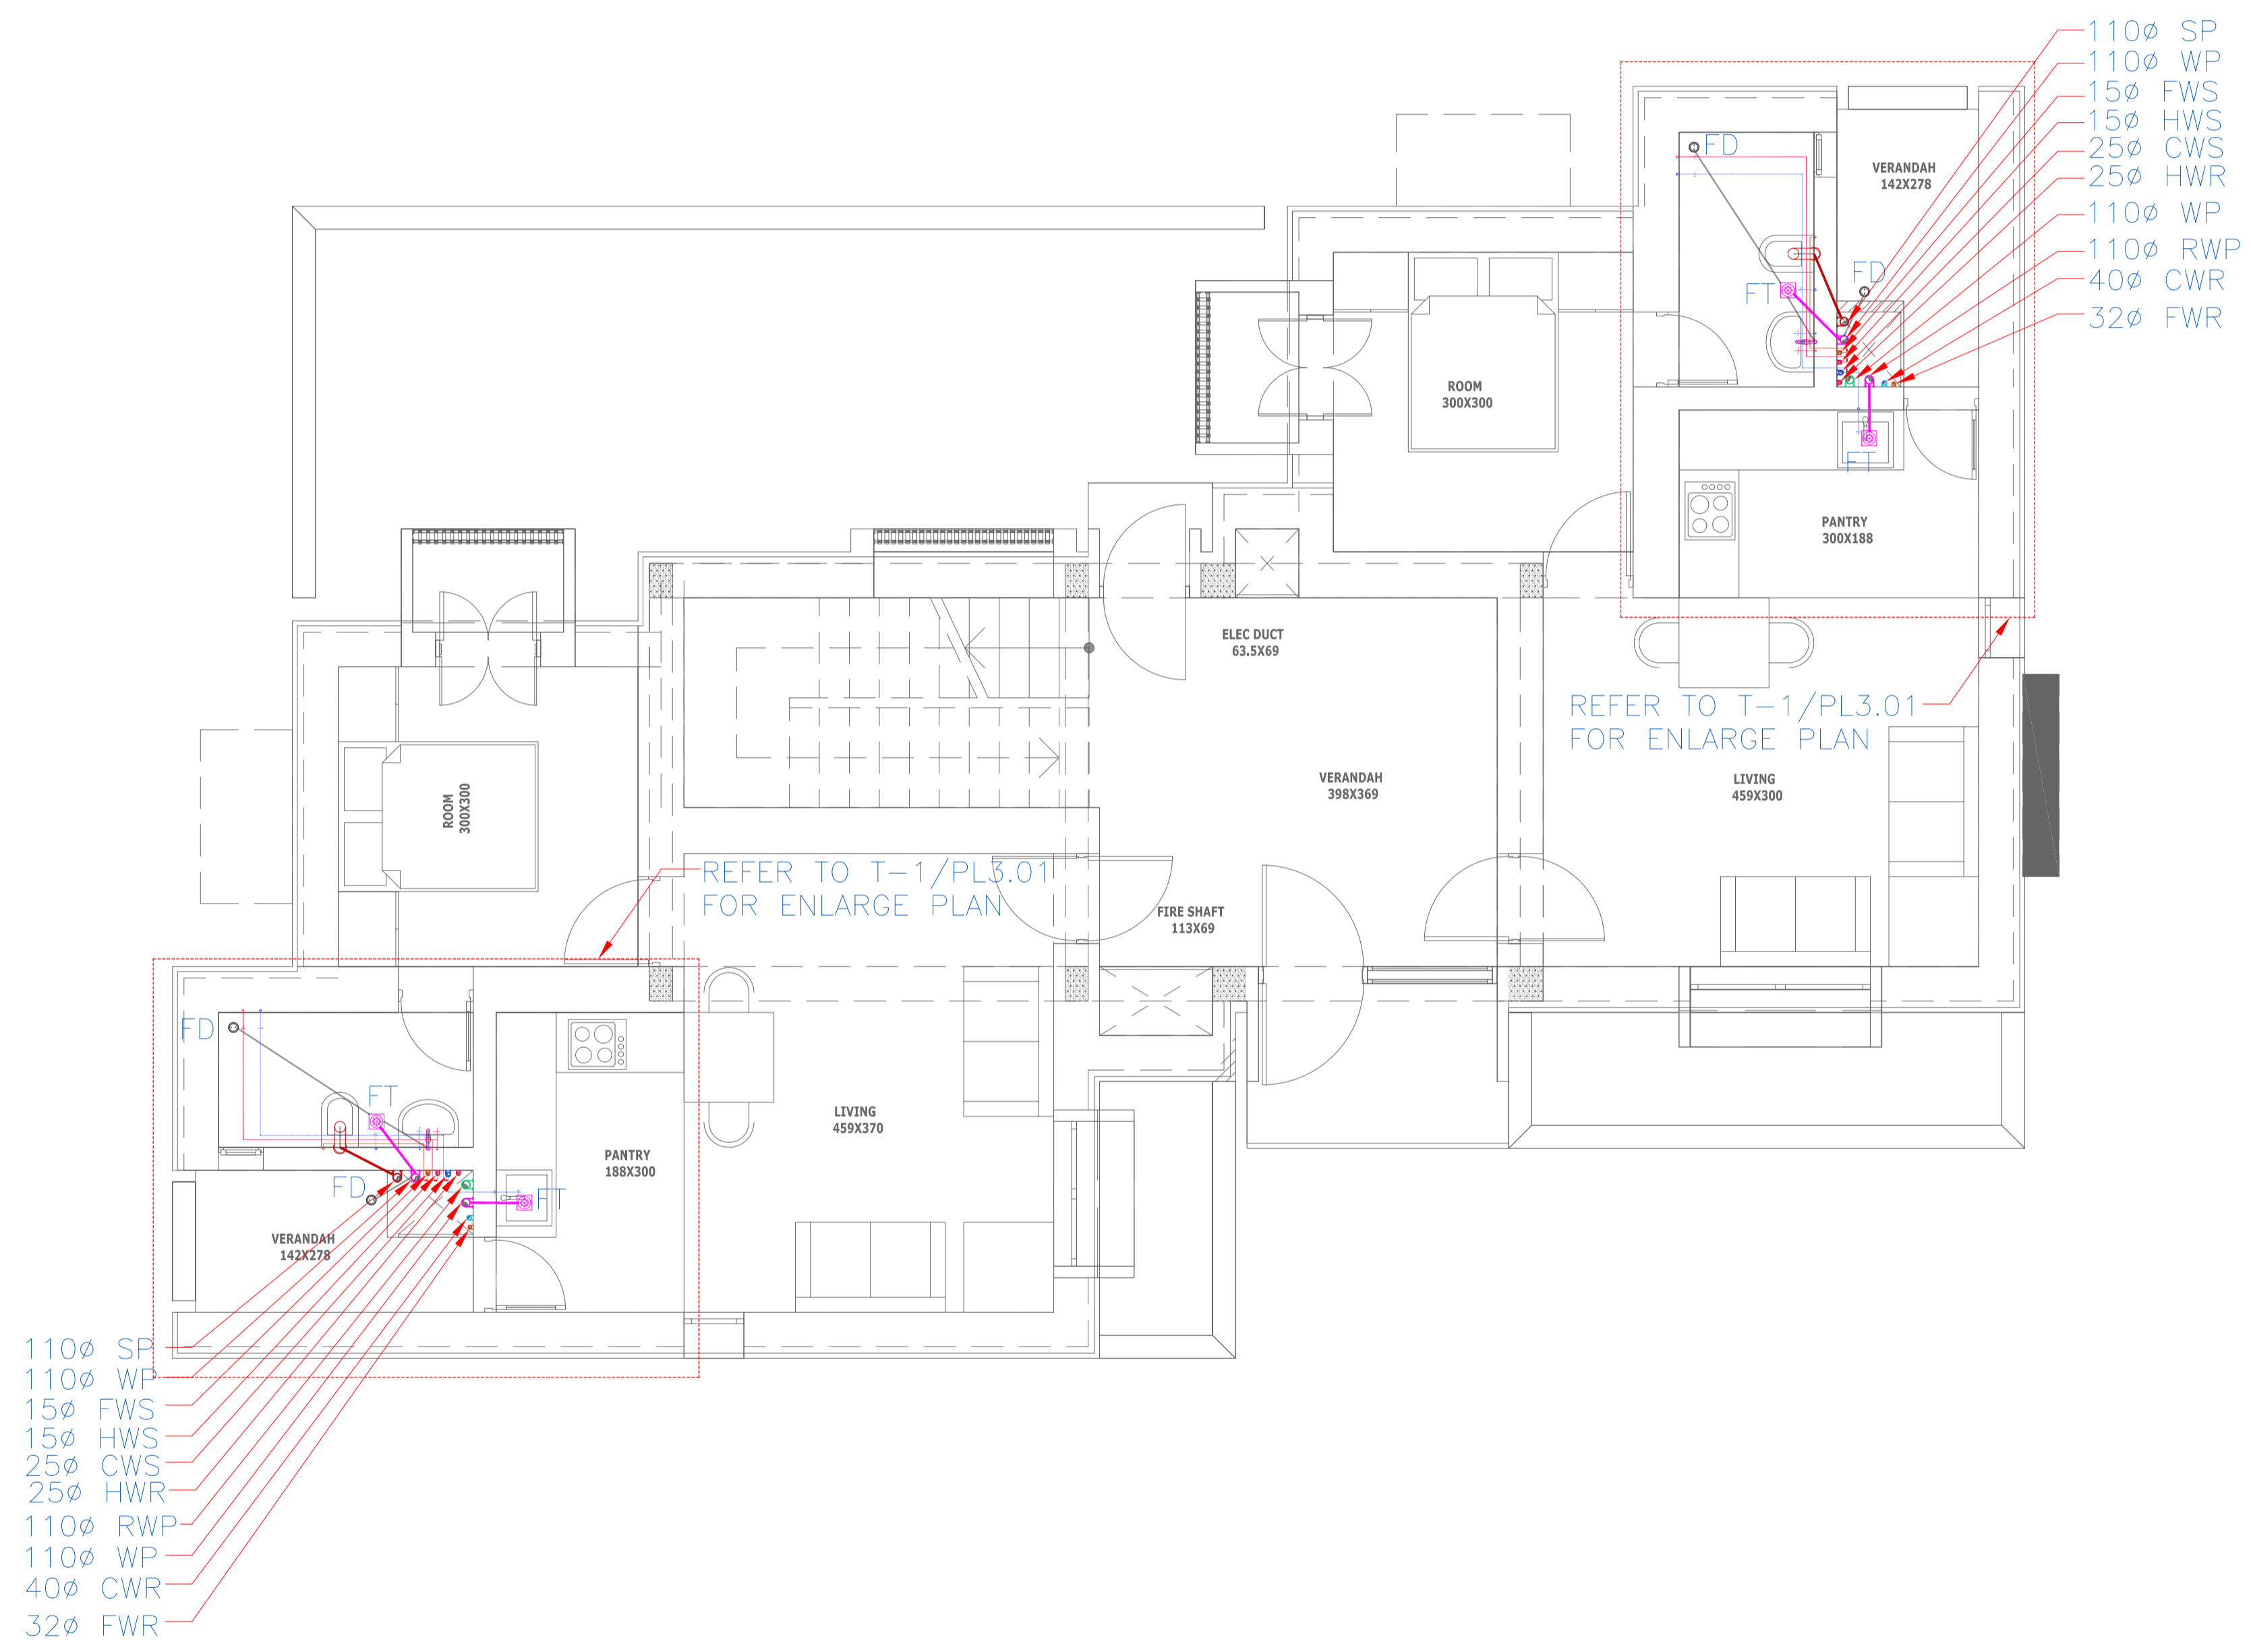

1 GROUND FLOOR PLAN - PLUMBING

No.	Date.	Remarks.
Revisions		

Date	Prints	Issued to	Date	Prints	Issued to
Distribution of Prints					



- Consultants**
- Structural Consultants**
VR SHAH Consulting Engineers
 - Services Consultants**
dbHMS
2nd Floor, D-62, Sector -2,
Noida - 201301
www.dbhms.in
 - Landscape Consultants**
Earthscapes Consultancy Pvt Ltd
 - Road and Pathways Consultants**
Arhmm Infra Consultants LLP

Project
Nalanda University, Rajgir, Bihar

Title
GROUND FLOOR PLAN - PLUMBING
FOR TENDER

Dealt : JK	Drawing No.
Checked : AT	NUC(1)-MSH-P2.1
Scale : 1:50	Aprd By : VM
Date : 20.05.2016	