


LEGEND		
S.No	SYMBOL	DESCRIPTION
1.	⊙	9LTR WATER CO ₂ FIRE EXTINGUISHER
2.	▶	2KG DRY POWDER FIRE EXTINGUISHER

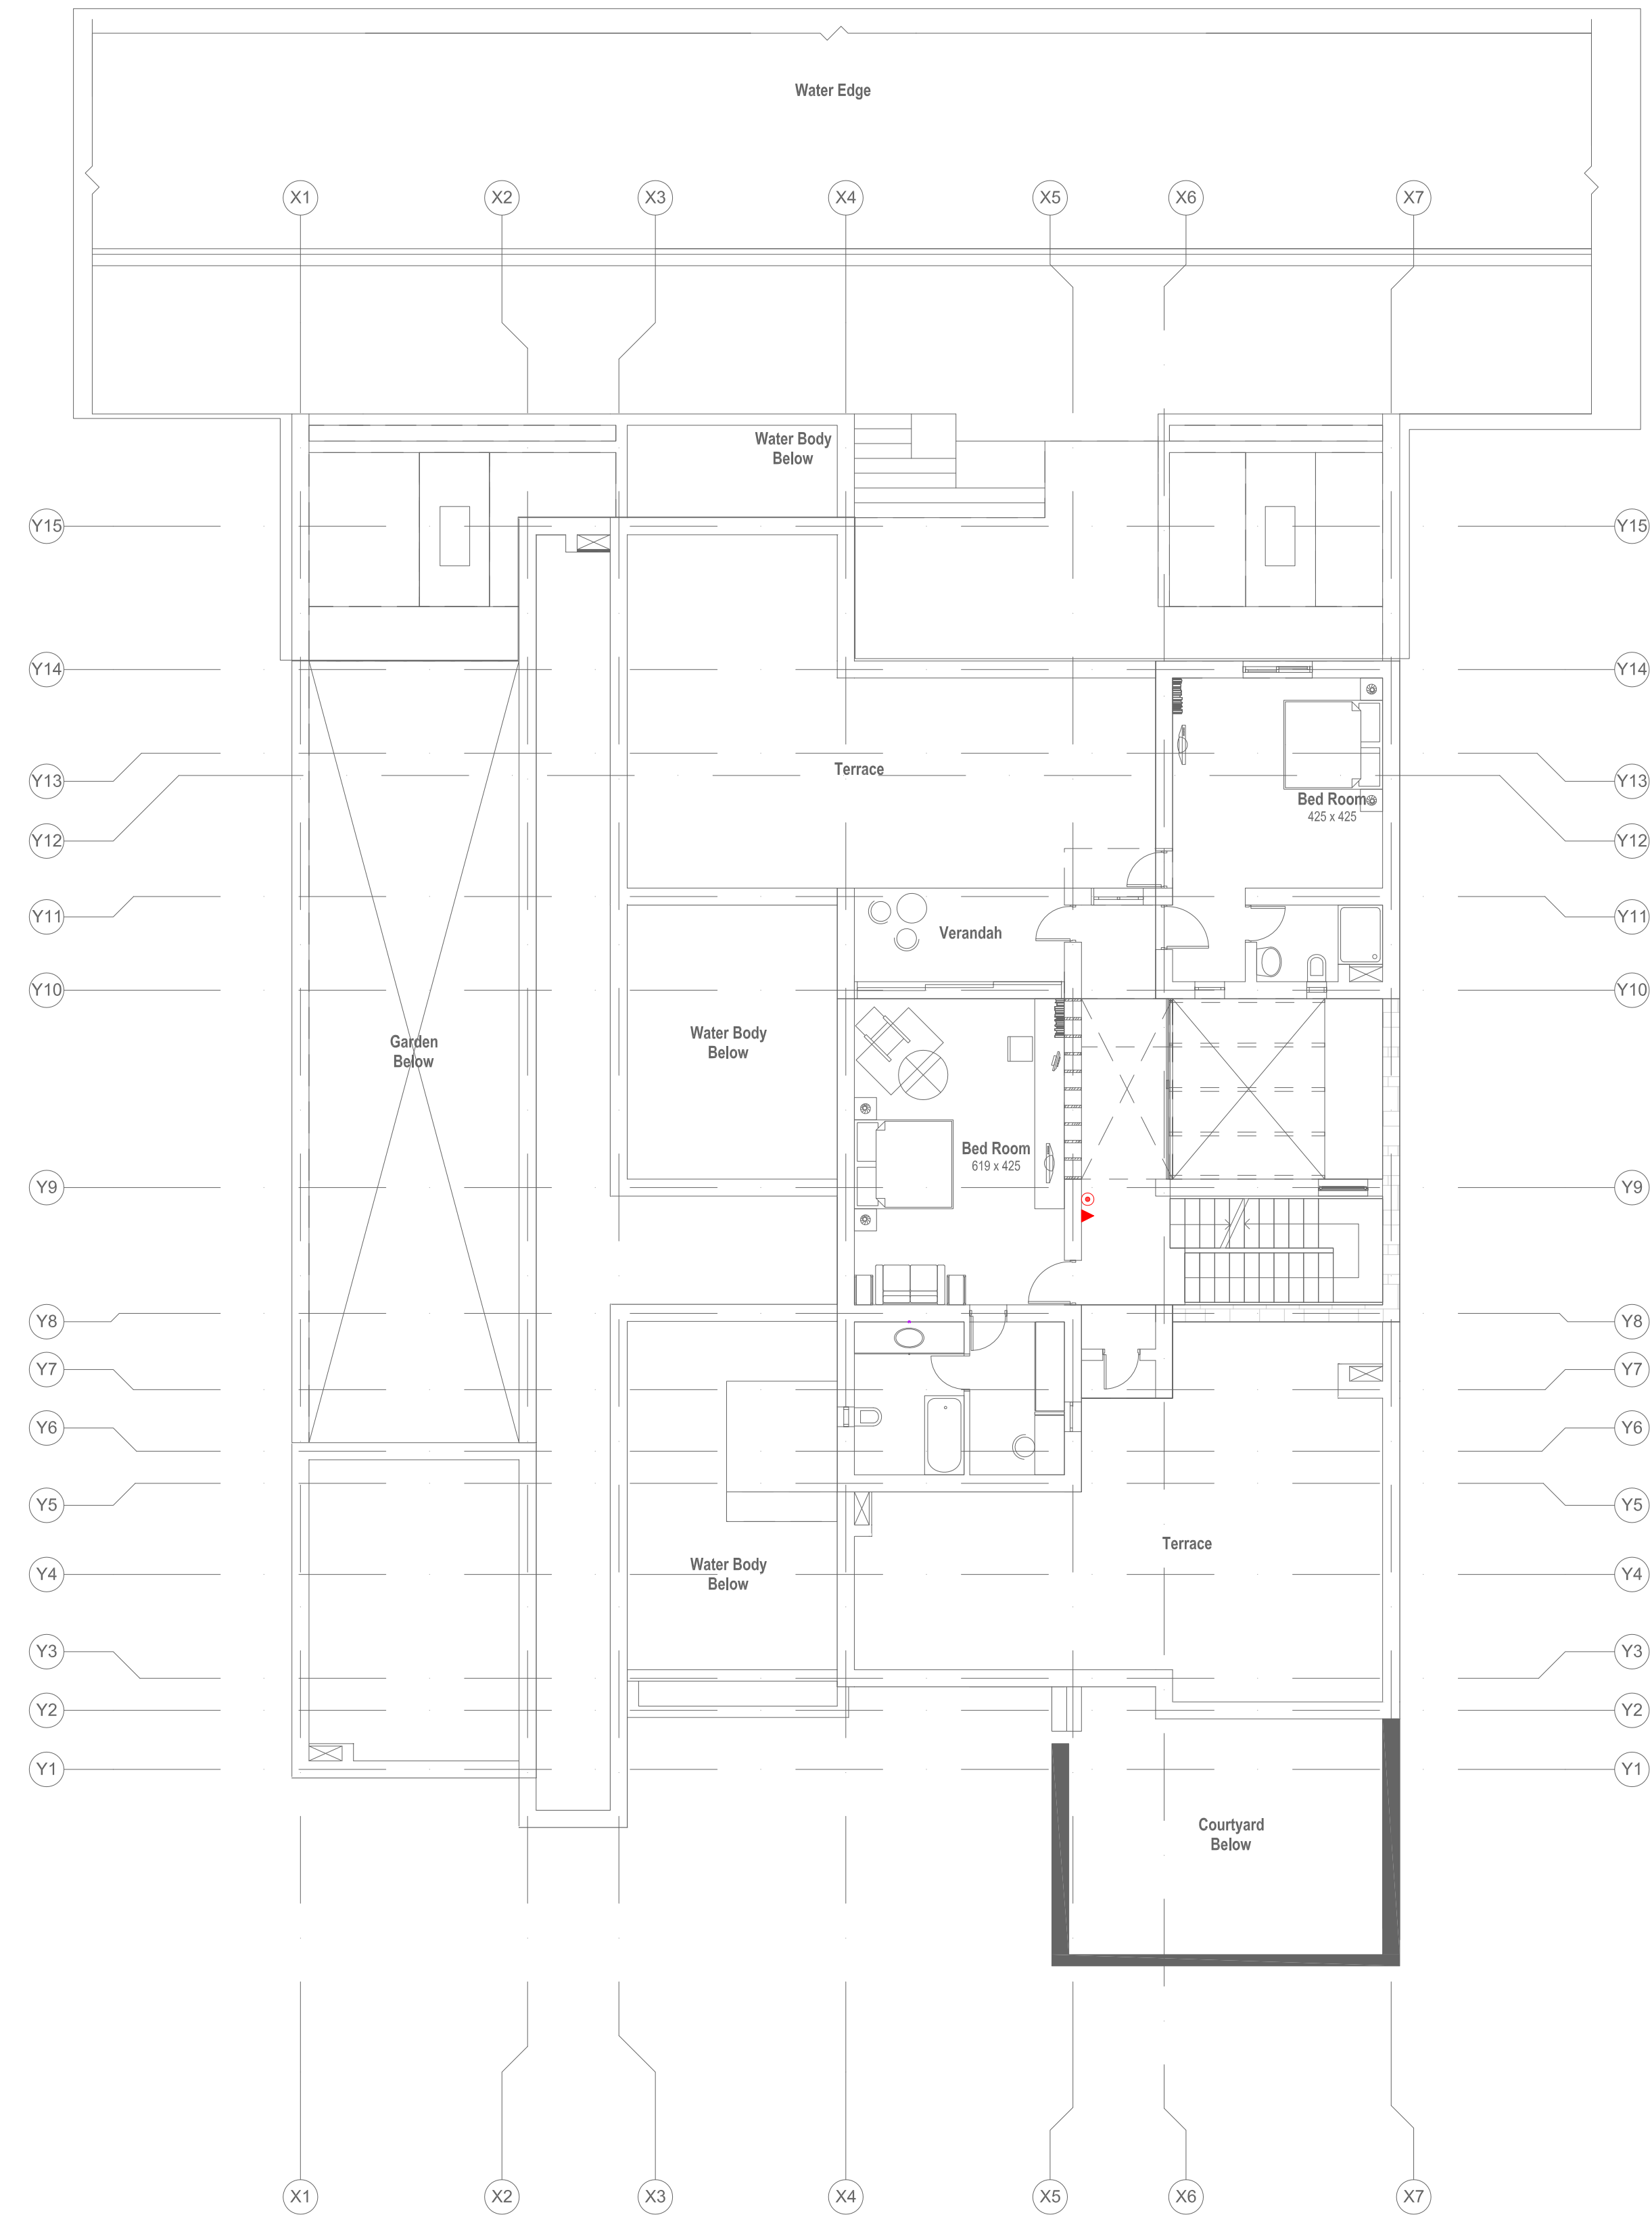

1 FIRST FLOOR PLAN - FIRE FIGHTING

 
NOTES
 1. ALL DIMENSIONS SHALL BE CHECKED AND CO-RELATED WITH THE STRUCTURAL DRAWINGS AND ANY AMBIGUITY SHALL BE IMMEDIATELY BROUGHT TO THE NOTICE OF THE ARCHITECT BEFORE COMMENCEMENT OF THE WORK.
 2. ALL DIMENSIONS ARE IN CENTIMETERS UNLESS AND OTHERWISE SPECIFIED.
 3. ALL LEVELS ARE FINISHED LEVELS.
 4. ALL MARGINS, CLEARANCES ETC. REQUIRED AS PER BYE-LAWS SHOULD BE CHECKED AND PROVIDED BY THE CONTRACTOR AND ANY DEFICIENCIES FOUND SHOULD BE IMMEDIATELY BROUGHT TO THE NOTICE OF ARCHITECT BEFORE COMMENCEMENT OF WORK.

No.	Date.	Remarks.
-----	-------	----------

Revisions					

Date	Prints	Issued to	Date/Prints	Issued to
------	--------	-----------	-------------	-----------

Distribution of Prints

Key Plan 

- Consultants**
- **Structural Consultants**
VR SHAH Consulting Engineers
 - **Services Consultants**
 dbHMS
2nd Floor, D-62, Sector -2,
Noida - 201301
www.dbhms.in
 - **Landscape Consultants**
Earthscape Consultancy Pvt Ltd
 - **Road and Pathways Consultants**
Arhmm Infra Consultants LLP

Project
Nalanda University, Rajgir, Bihar

Title
 FIRST FLOOR PLAN -
 FIRE FIGHTING
 FOR TENDER

Dealt : AT	Drawing No.
Checked : VM	NUC(1)-VC-FF2.2
Scale : 1:100	
Date : 20.05.2016	

VASTU SHILPA CONSULTANTS
 Architects | Planners | Urban Designers

Sangath, Thaltej Road, Ahmedabad - 380054
 Phone: 079 - 27454537 Fax: 079 - 27452006
 www.sangath.org e-mail: vsc@sangath.org