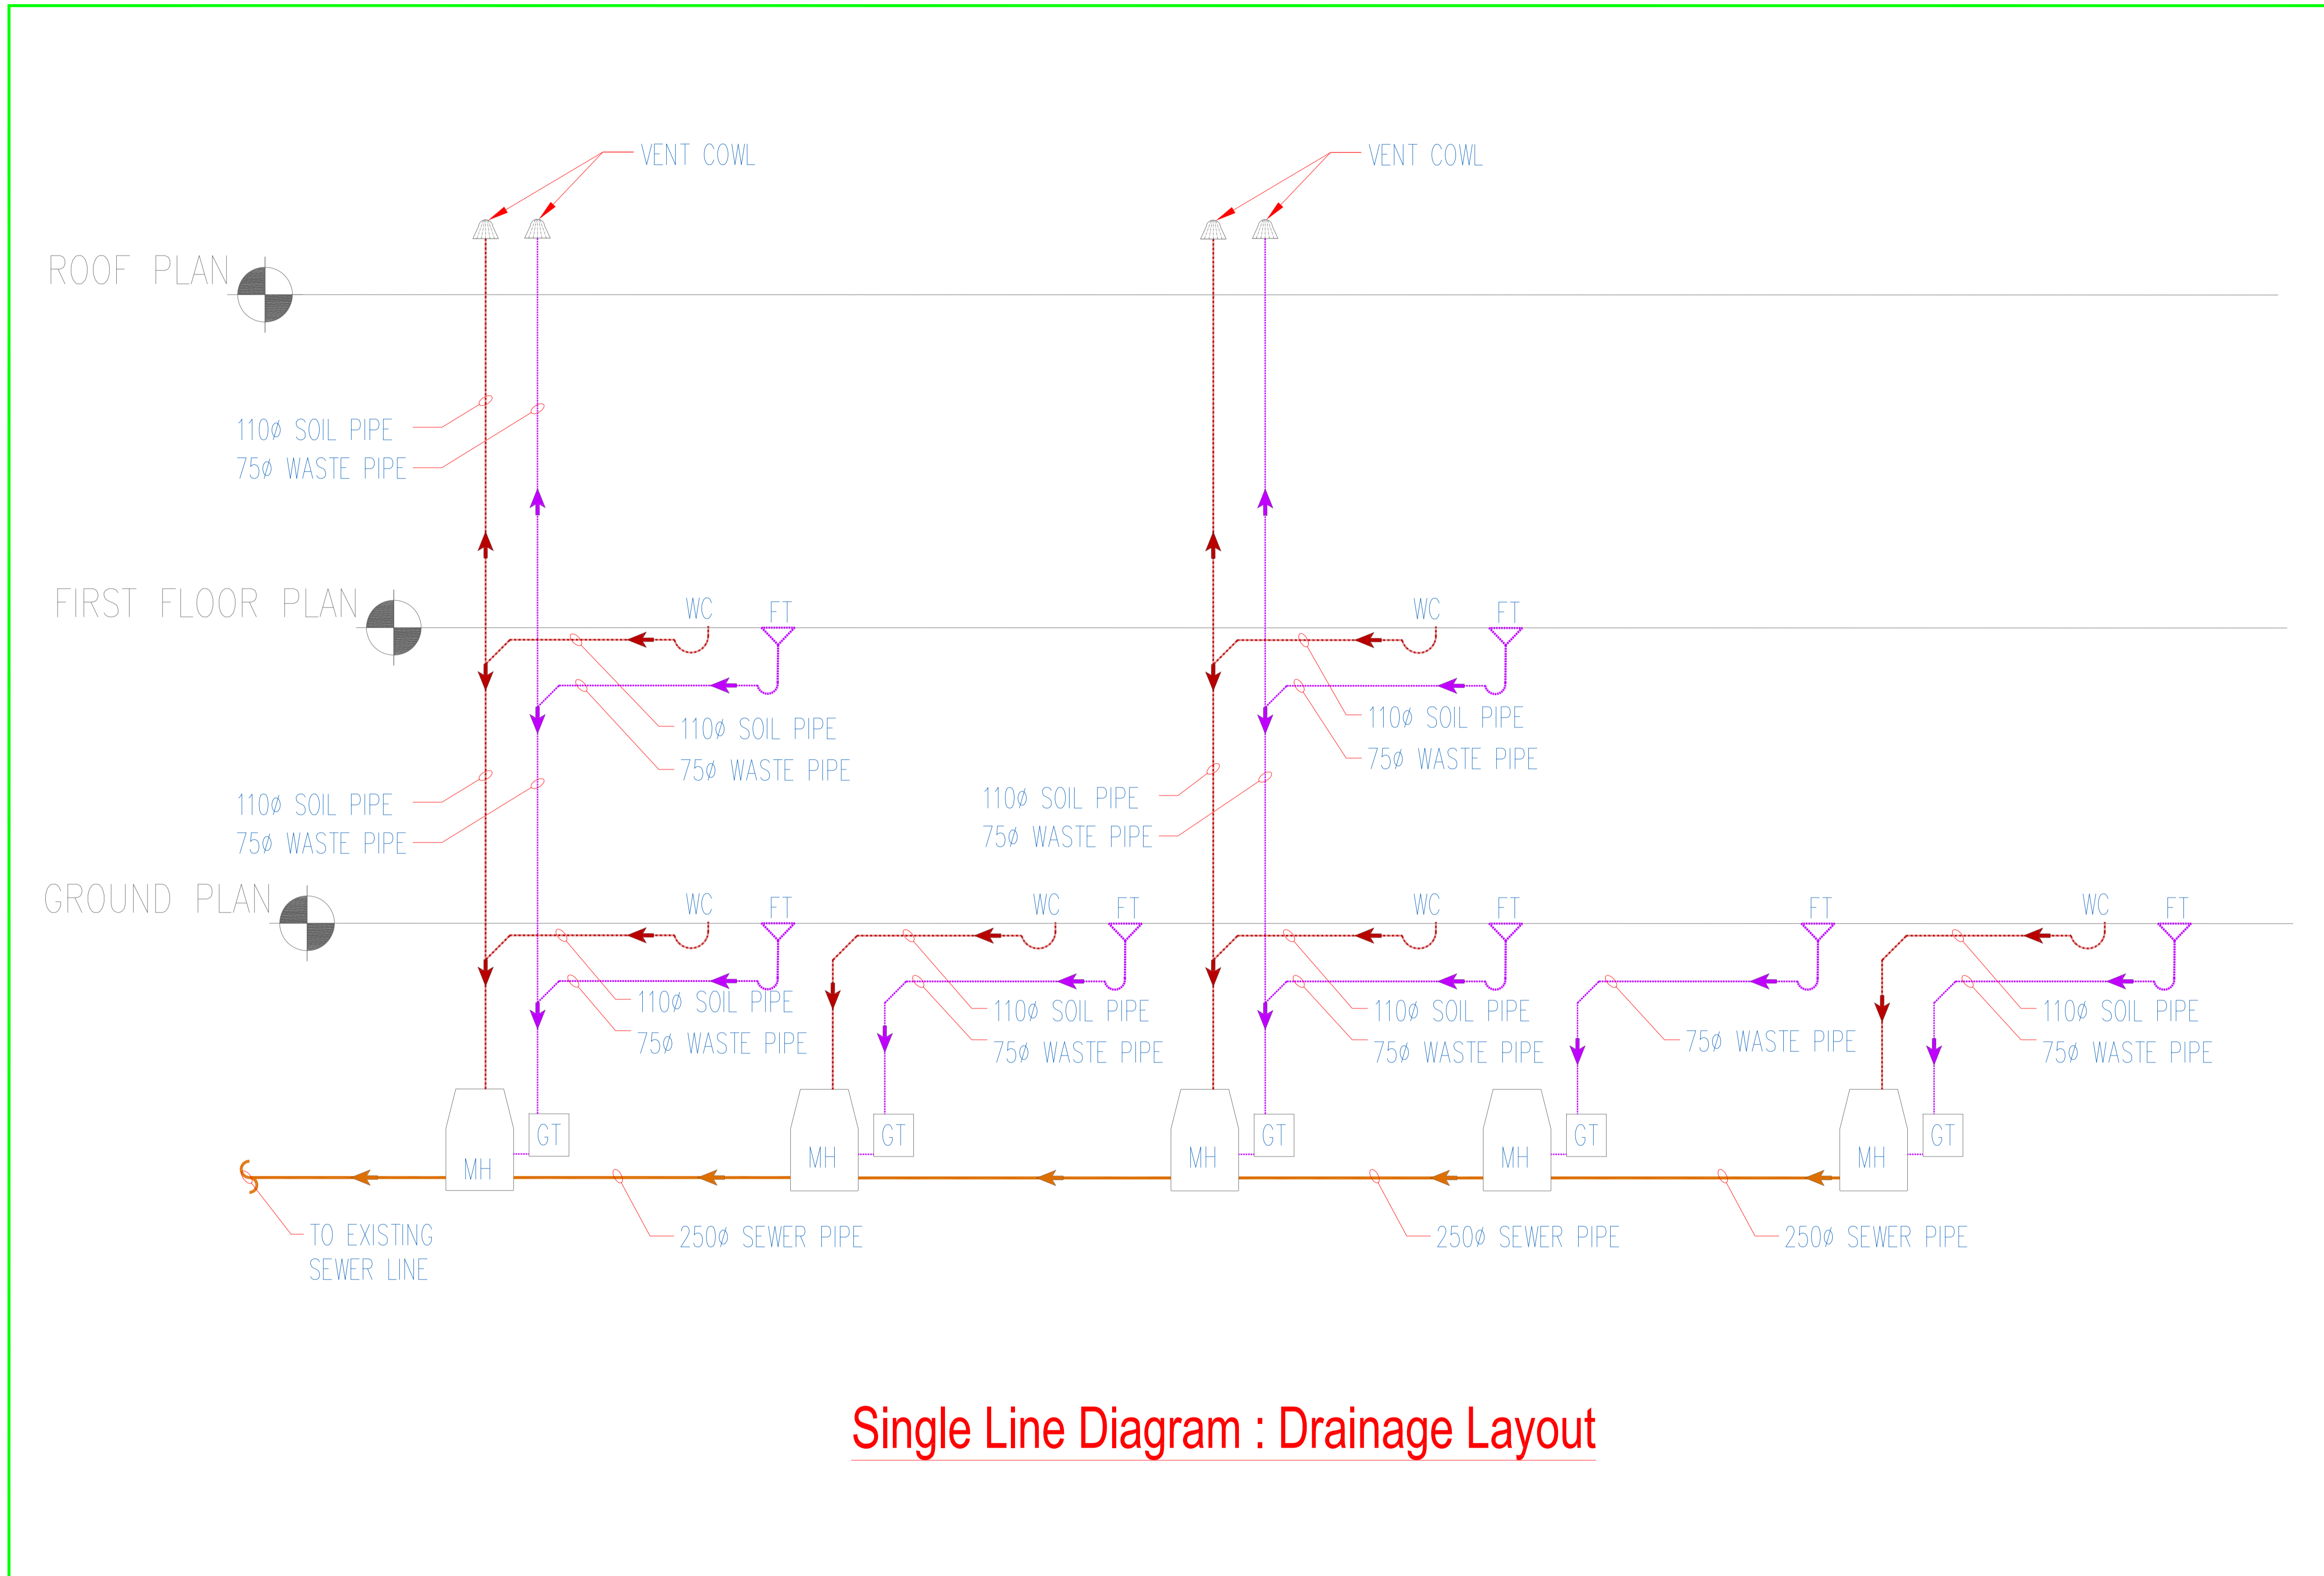


NOTES & INFORMATION

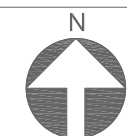

1. ALL DIMENSIONS ARE INDICATED IN MILLIMETERS UNLESS OTHERWISE SPECIFIED.
2. DIMENSIONS TO BE READ AND NOT MEASURED.
3. ANY DISCREPANCY FOUND SHALL BE BROUGHT TO THE NOTICE OF THE ARCHITECTS / ENGINEERS.
4. ALL DRAWINGS TO BE READ IN CONJUNCTION WITH RELEVANT STRUCTURAL, ARCHITECTURAL AND SERVICES DRAWINGS.



**Single Line Diagram : Drainage Layout**

No.	Date.	Remarks.
Revisions		

Date	Prints	Issued to	Date	Prints	Issued to

- Distribution of Prints
- Key Plan 
- Consultants
- Structural Consultants**  
VR SHAH Consulting Engineers
  - Services Consultants**  
 dbHMS  
2nd Floor, D-62, Sector -2,  
Noida - 201301  
www.dbhms.in
  - Landscape Consultants**  
Earthscapes Consultancy Pvt Ltd
  - Road and Pathways Consultants**  
Arhmm Infra Consultants LLP

Project

**Nalanda University, Rajgir, Bihar**

Title

SINGLE LINE DIAGRAM –  
DRAINAGE  
FOR TENDER

Dealt :	JK	Drawing No.
Checked :	AT	NUC-FRH-P4.2
Scale :	1:150	
Date :	20.05.2016	

**VASTU SHILPA CONSULTANTS**  
Architects | Planners | Urban Designers

'Sangath', Thaltej Road, Ahmedabad - 380054  
Phone: 079 - 27454537 Fax: 079 - 27452006  
www.sangath.org e-mail: vsc@sangath.org